

Design Team

Design A/E	Jacobs Engineering
Drawn	PAOLA CARRARA
Checked	FABIO VERSETTI
Approved	PAOLO DI VERA
Company Project No.	10000000000000000000
M.S. Project No.	00000000000000000000

PROJECT MANAGEMENT A/E


Project Manager	MICOLA CARONDI
Design Manager	PAOLO DI VERA

Revisions

No.	Date	Description
A	08/09/2024	ALLEGATO RELAZIONE ACUSTICA

Registration



Key Plan

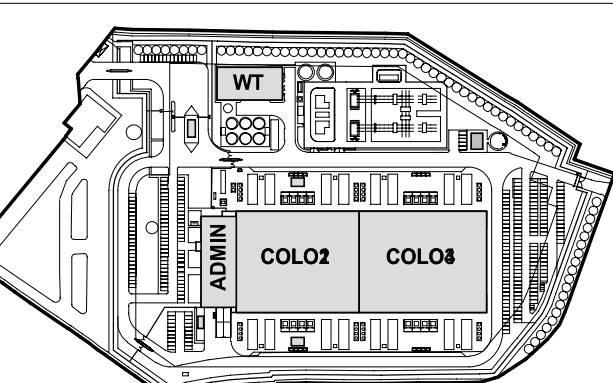

TRUE NORTH

Bar Code

Sheet Title/Number

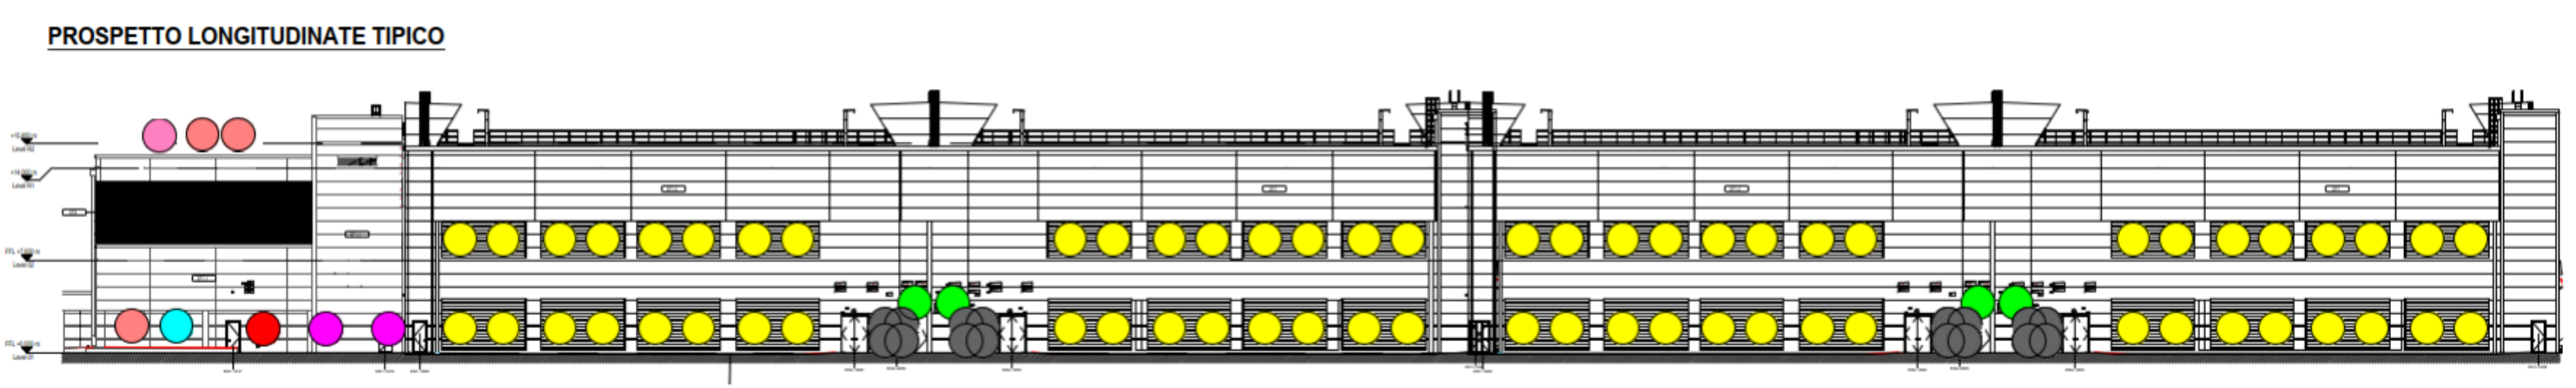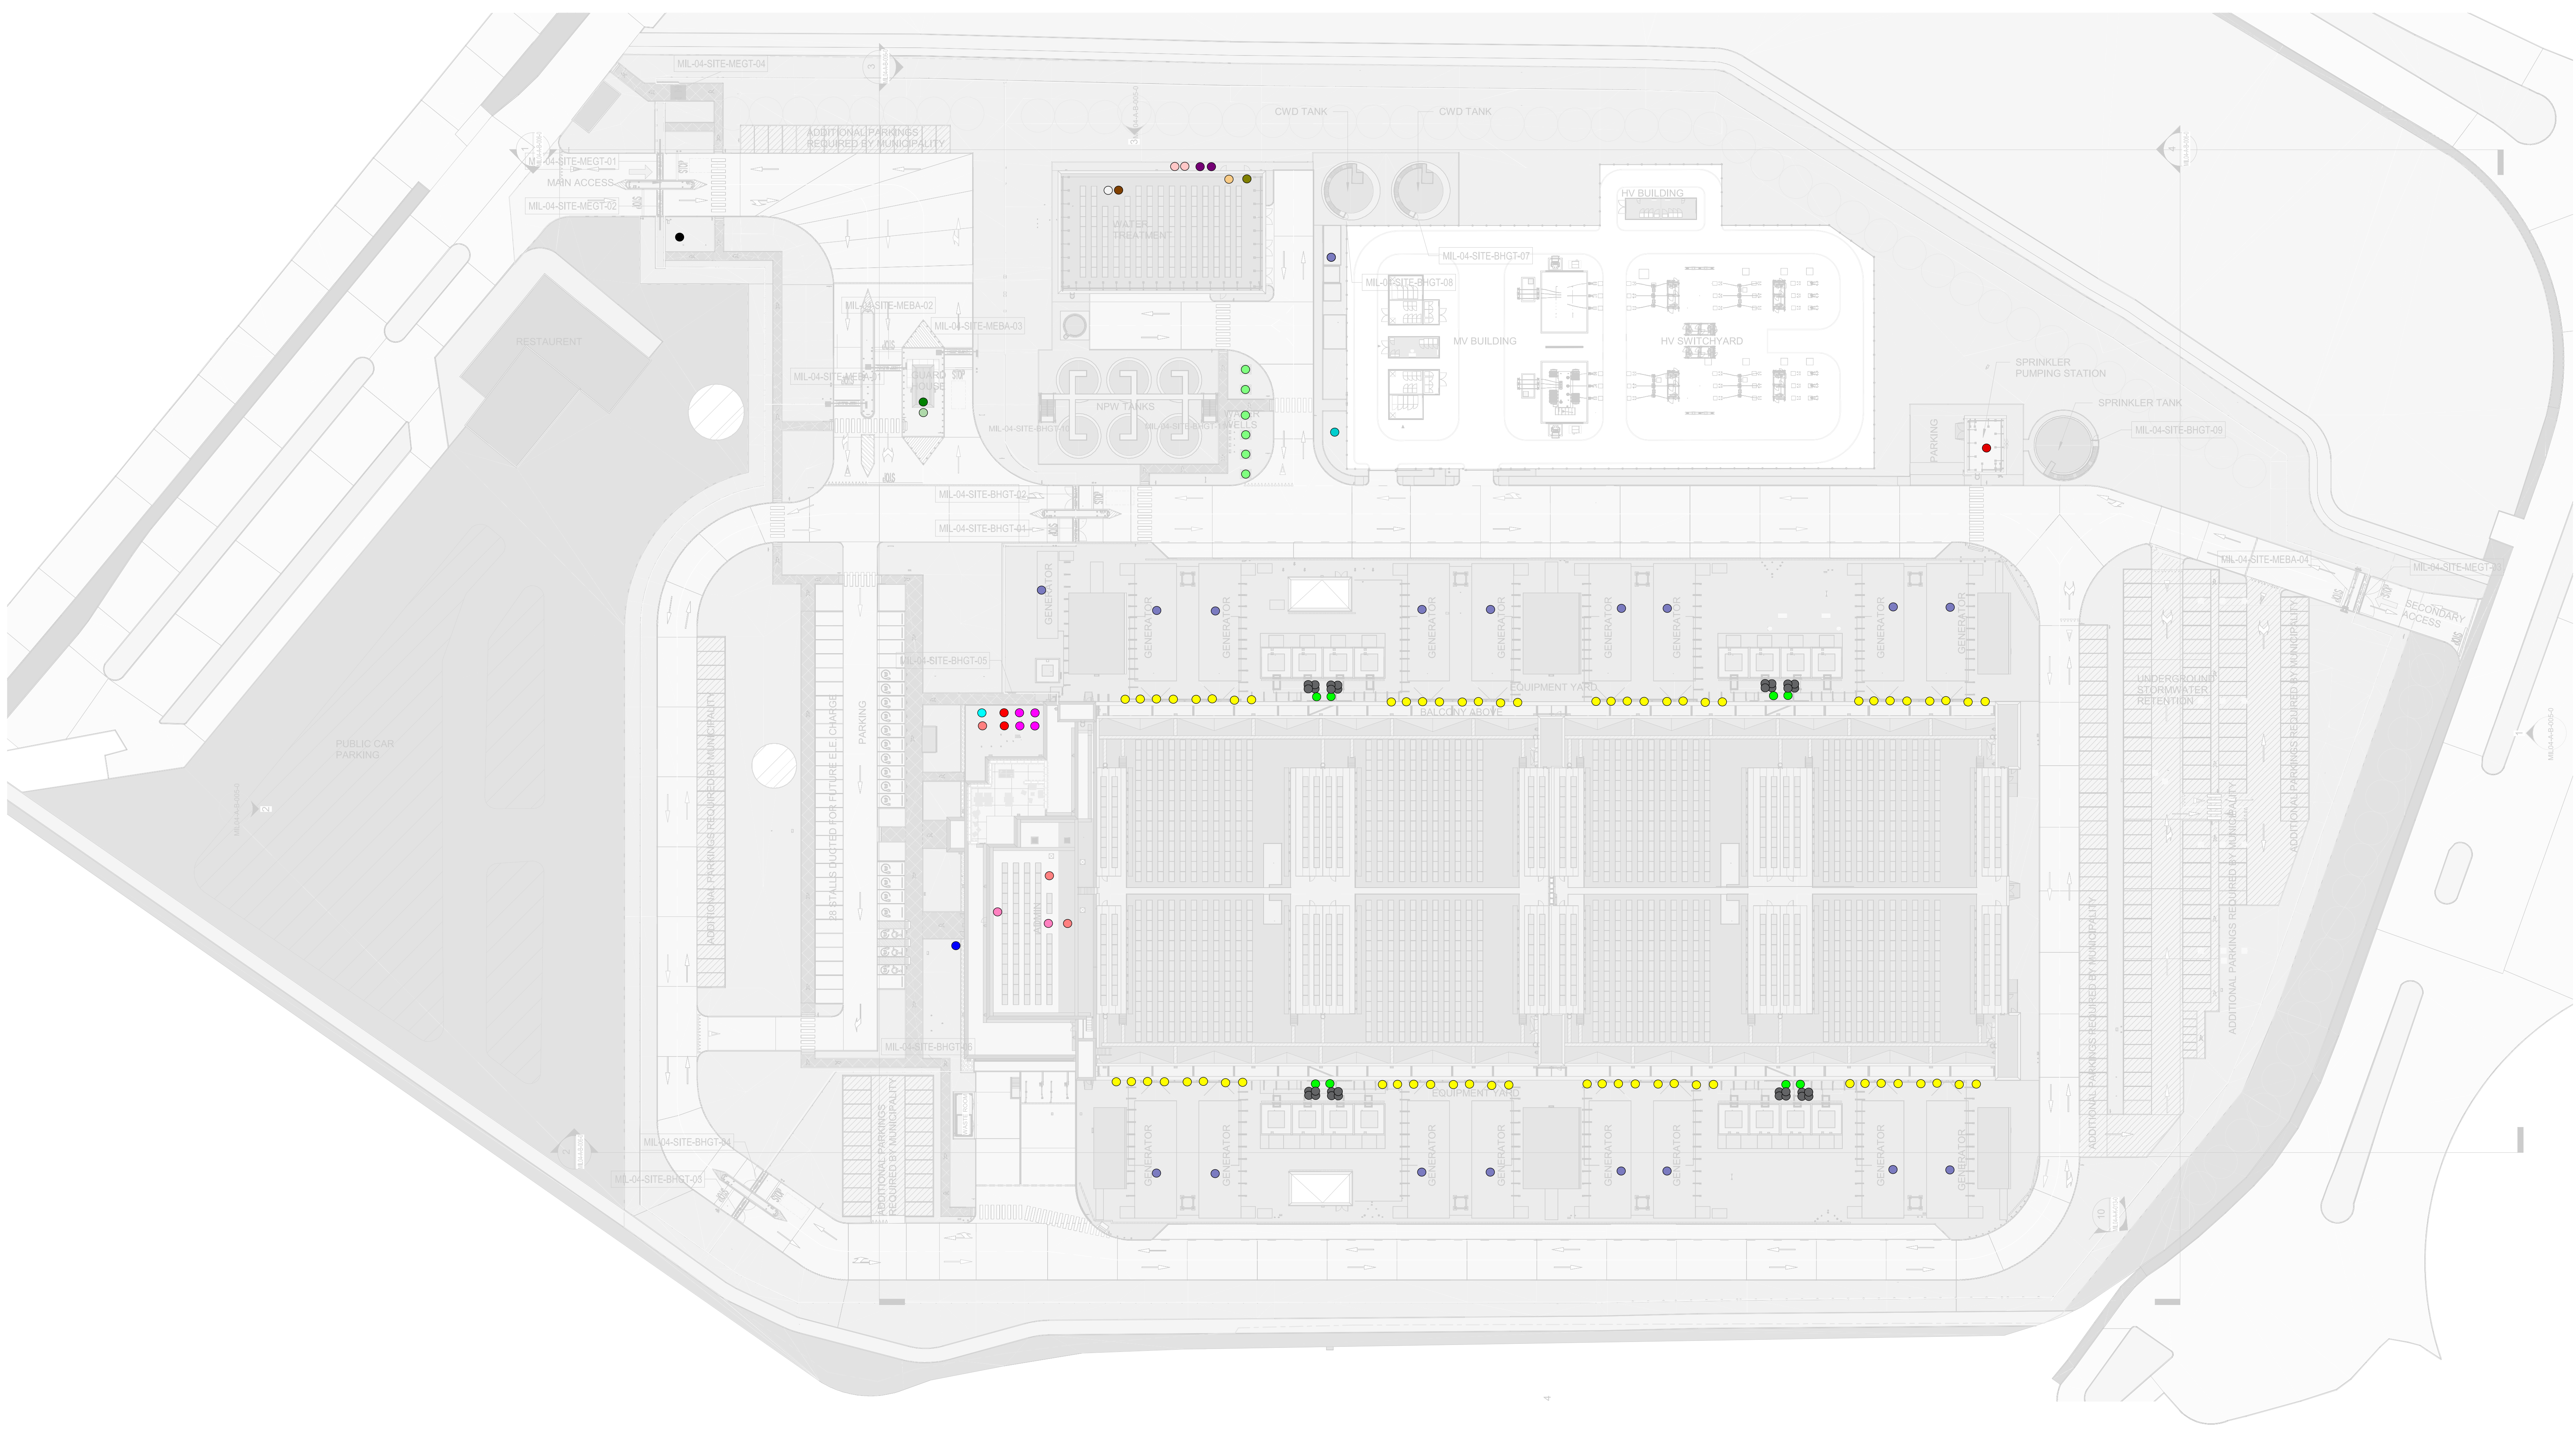

ACOUSTIC LEGEND

- 1. UNITA TRATTAMENTO ARIA INTERNA AL COLO
- 2. VRV CONDENSATORI ESTERNI LOCALI BATTERIE (COLO)
- 3. VENTILATORI DI ESPULSIONE LOCALI BATTERIE (COLO)
- 4. UTA ADMIN
- 5. VRV CONDENSATORI ESTERNI ADMIN - CRITICI
- 6. VRV CONDENSATORI ESTERNI ADMIN - NON CRITICI
- 7. VRV CONDENSATORI ESTERNI ADMIN - ACS
- 8. RECUPERATORE BAGNI ADMIN
- 9. ESTRATTORI ADMIN
- 10. RECUPERATORE WTB 1
- 11. RECUPERATORE WTB 2
- 12. VRV CONDENSATORI ESTERNI WTB - CRITICI
- 13. VRV CONDENSATORI ESTERNI WTB - NON CRITICI
- 14. ESTRATTORI WTB
- 15. WTB
- 16. POZZI
- 17. RECUPERATORE GUARD HOUSE
- 18. VRV CONDENSATORI ESTERNI GUARD HOUSE
- 19. POMPA FIRE
- 20. SOLLEVAMENTO ACQUE NERE
- 21. SOLLEVAMENTO CWD
- 22. GRUPPI ELETTROGENI

OVERALL SITE PLAN - PLANIMETRIA GENERALE
1:500