


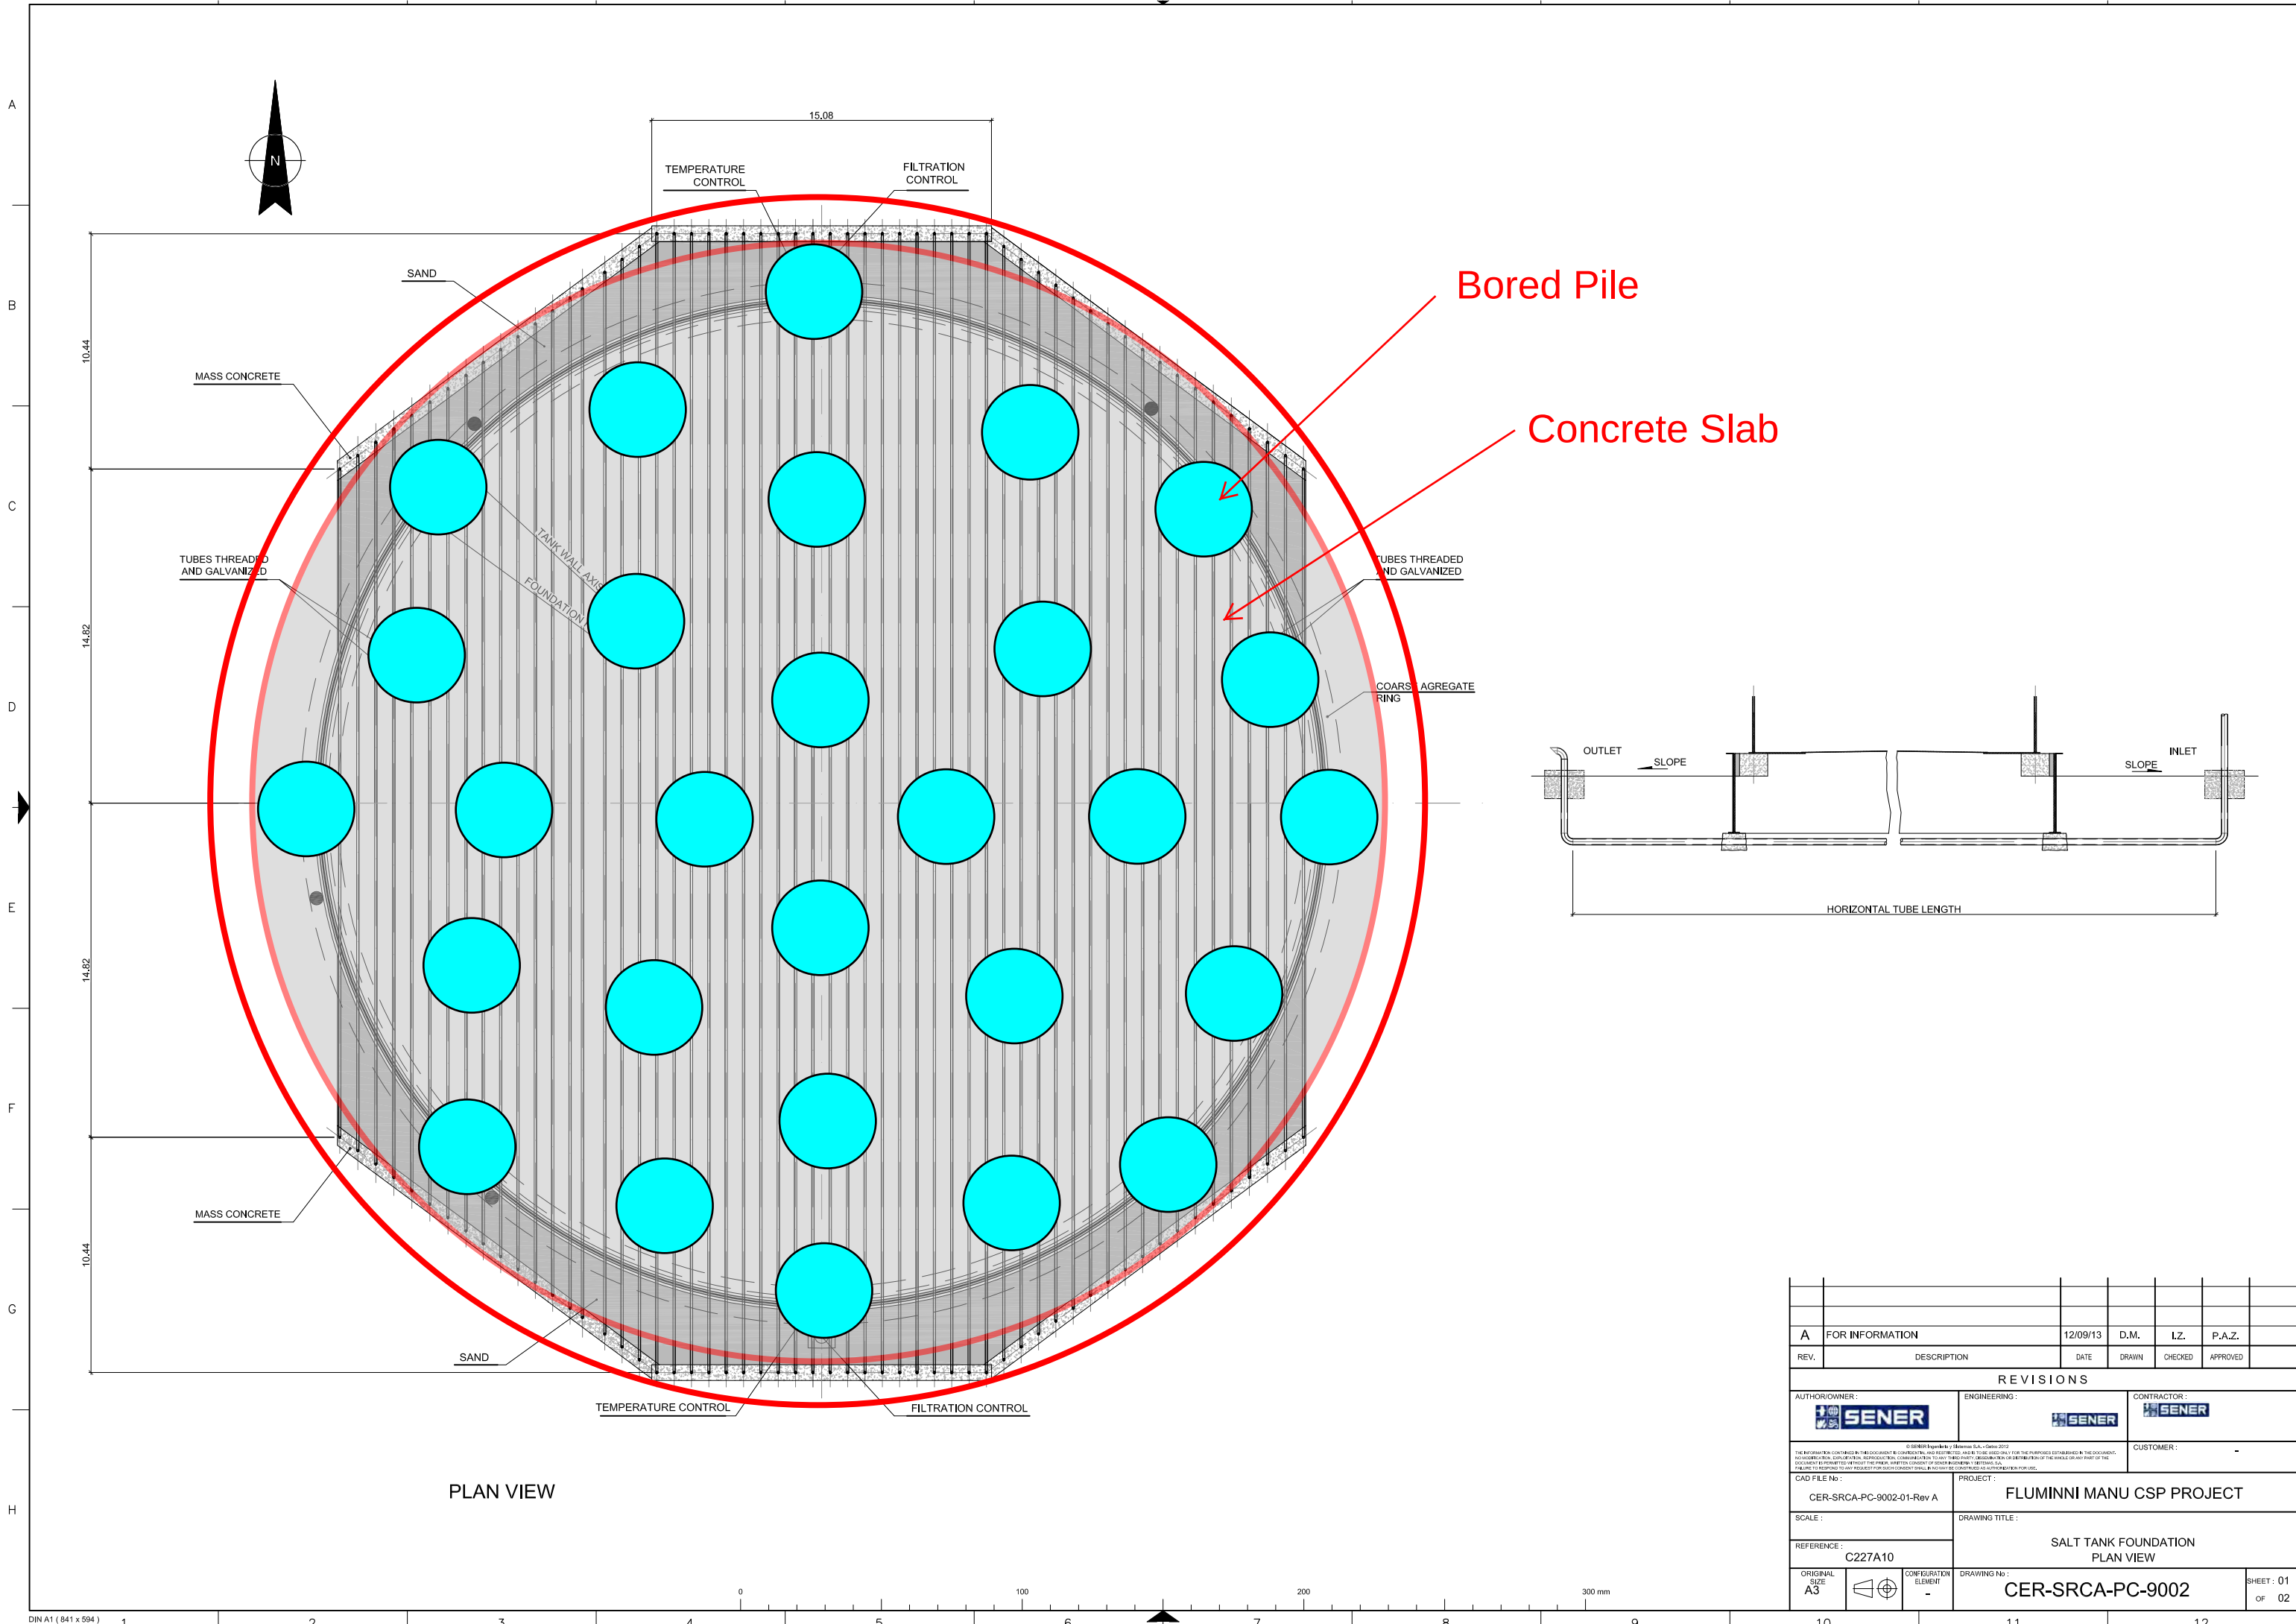

A		FOR INFORMATION	12/09/13	D.M.	I.Z.	P.A.Z.
REV.	DESCRIPTION		DATE	DRAWN	CHECKED	APPROVED
REVISIONS						
AUTHOR/OWNER:		ENGINEERING:		CONTRACTOR:		
						
© SENER Ingeniería y Sistemas S.A. - Cádiz 2012 All rights reserved. This document is CONFIDENTIAL AND NOT BE LOANED, REPRODUCED OR COPIED WITHOUT THE EXPRESS WRITTEN PERMISSION OF SENER INGENIERIA Y SISTEMAS S.A. THE INFORMATION CONTAINED HEREIN IS UNCLASSIFIED AND NOT BE RELEASED FOR THE PURPOSES ESTABLISHED IN THE DOCUMENT. DOCUMENT IS RELEASED FOR THE PUBLIC UNDER THE CONDITION OF SENER INGENIERIA Y SISTEMAS S.A. (S.I.S.A.) - C.A.D. 2012 ALL RIGHTS RESERVED. THIS DOCUMENT IS CONFIDENTIAL AND NOT BE LOANED, REPRODUCED OR COPIED WITHOUT THE EXPRESS WRITTEN PERMISSION OF SENER INGENIERIA Y SISTEMAS S.A.				CUSTOMER: -		
CAD FILE No:		PROJECT:				
CER-SRCA-PC-9002-01-Rev A		FLUMINNI MANU CSP PROJECT				
SCALE:		DRAWING TITLE:				
REFERENCE:		SALT TANK FOUNDATION PLAN VIEW				
C227A10		DRAWING No:				
ORIGINAL SIZE A3		CONFIGURATION ELEMENT -	DRAWING No: CER-SRCA-PC-9002			SHEET: 01 OF 02