


**ALLEGATO 1.B.3**  
**DISEGNO BECHTEL LIMITED No. 24624-004-SLD-101,**  
**“DIAGRAMMA UNIFILARE TERMINALE GNL”,**  
**REV. A**

24624-004-3LD-101

THIS DRAWING AND THE DESIGN IT COVERS ARE THE PROPERTY OF BECHTEL LIMITED. THEY ARE MERELY LOANED TO YOU BY BECHTEL LIMITED. YOU ARE NOT TO REPRODUCE OR TRANSMIT THIS DRAWING OR THE DESIGN IT COVERS IN ANY MANNER OR BY ANY MEANS, ELECTRONIC OR MECHANICAL, INCLUDING PHOTOCOPYING, RECORDING, OR BY ANY INFORMATION STORAGE AND RETRIEVAL SYSTEM, WITHOUT THE WRITTEN CONSENT OF BECHTEL LIMITED.

001 TV/66 - A-5200

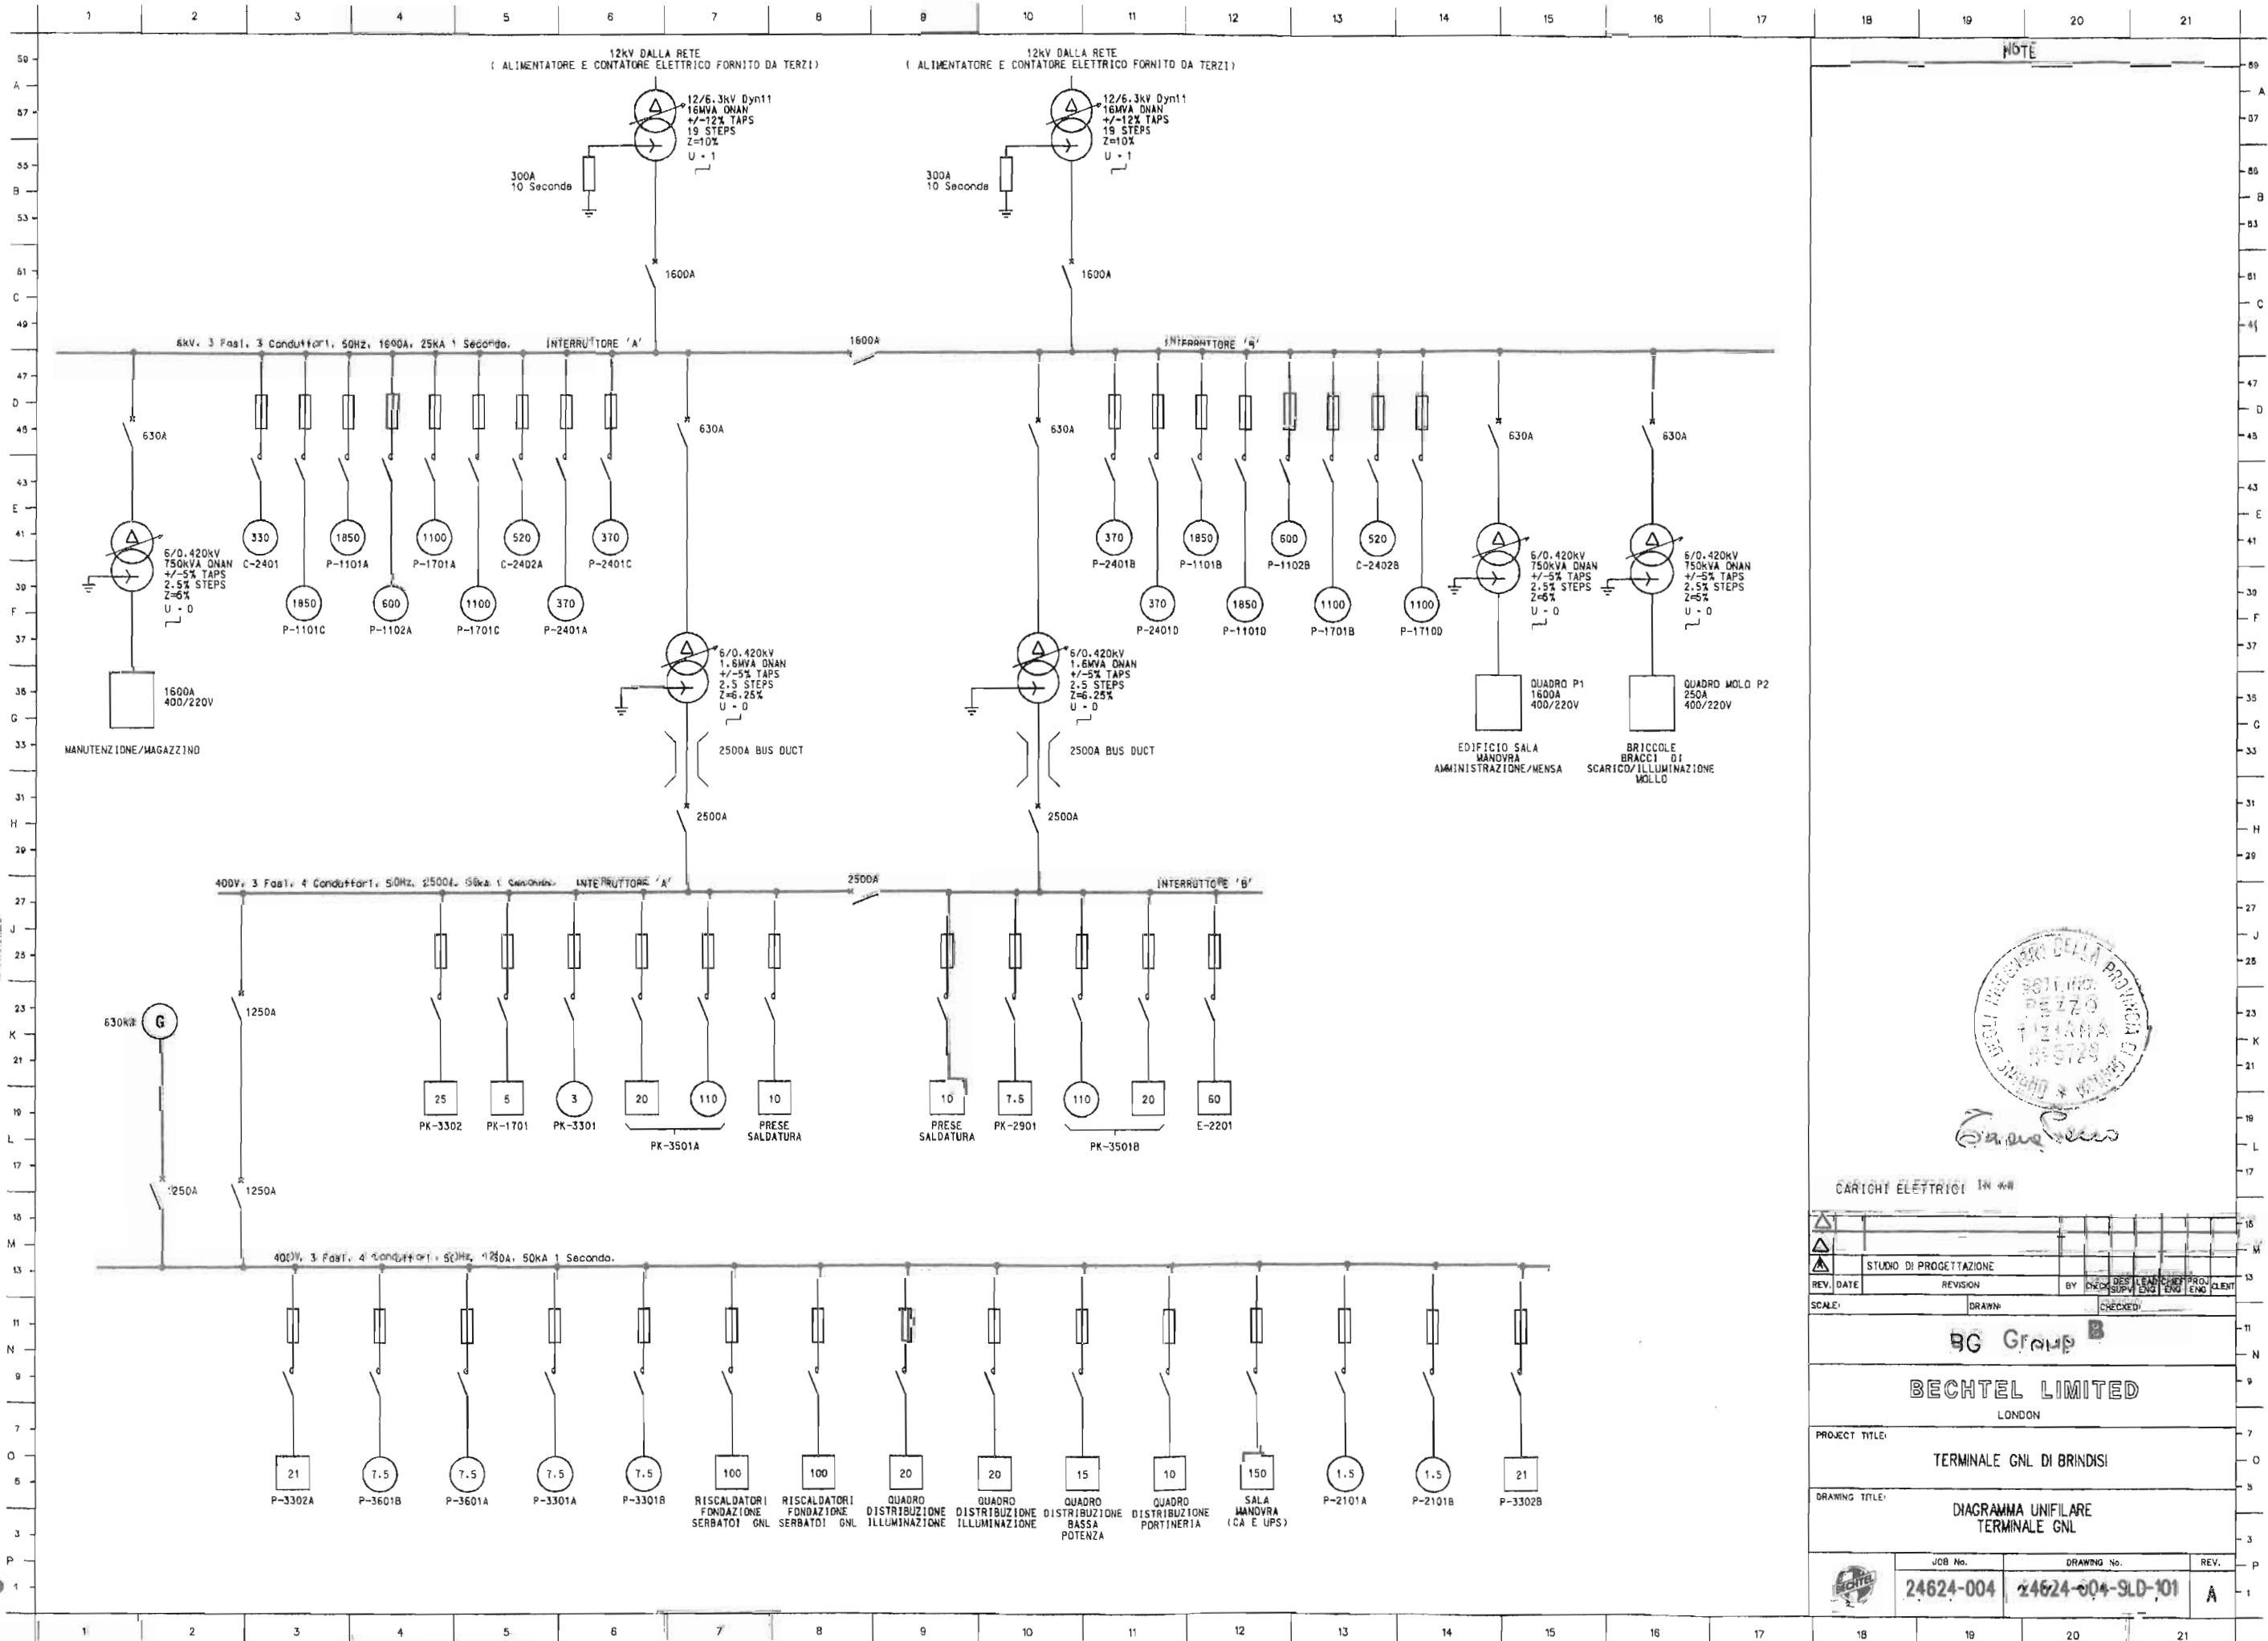

NOTE



CARICHI ELETTRICI IN kW

STUDIO DI PROGETTAZIONE			
REV. DATE	REVISION	BY	CLIENT
SCALE	DRAWN	CHECKED	PROJ. ENG.
<b>BG Group</b>			
<b>BECHTEL LIMITED</b> LONDON			
PROJECT TITLE: TERMINALE GNL DI BRINDISI			
DRAWING TITLE: DIAGRAMMA UNIFILARE TERMINALE GNL			
JOB No.	DRAWING No.	REV.	
24624-004	24624-004-3LD-101	A	