


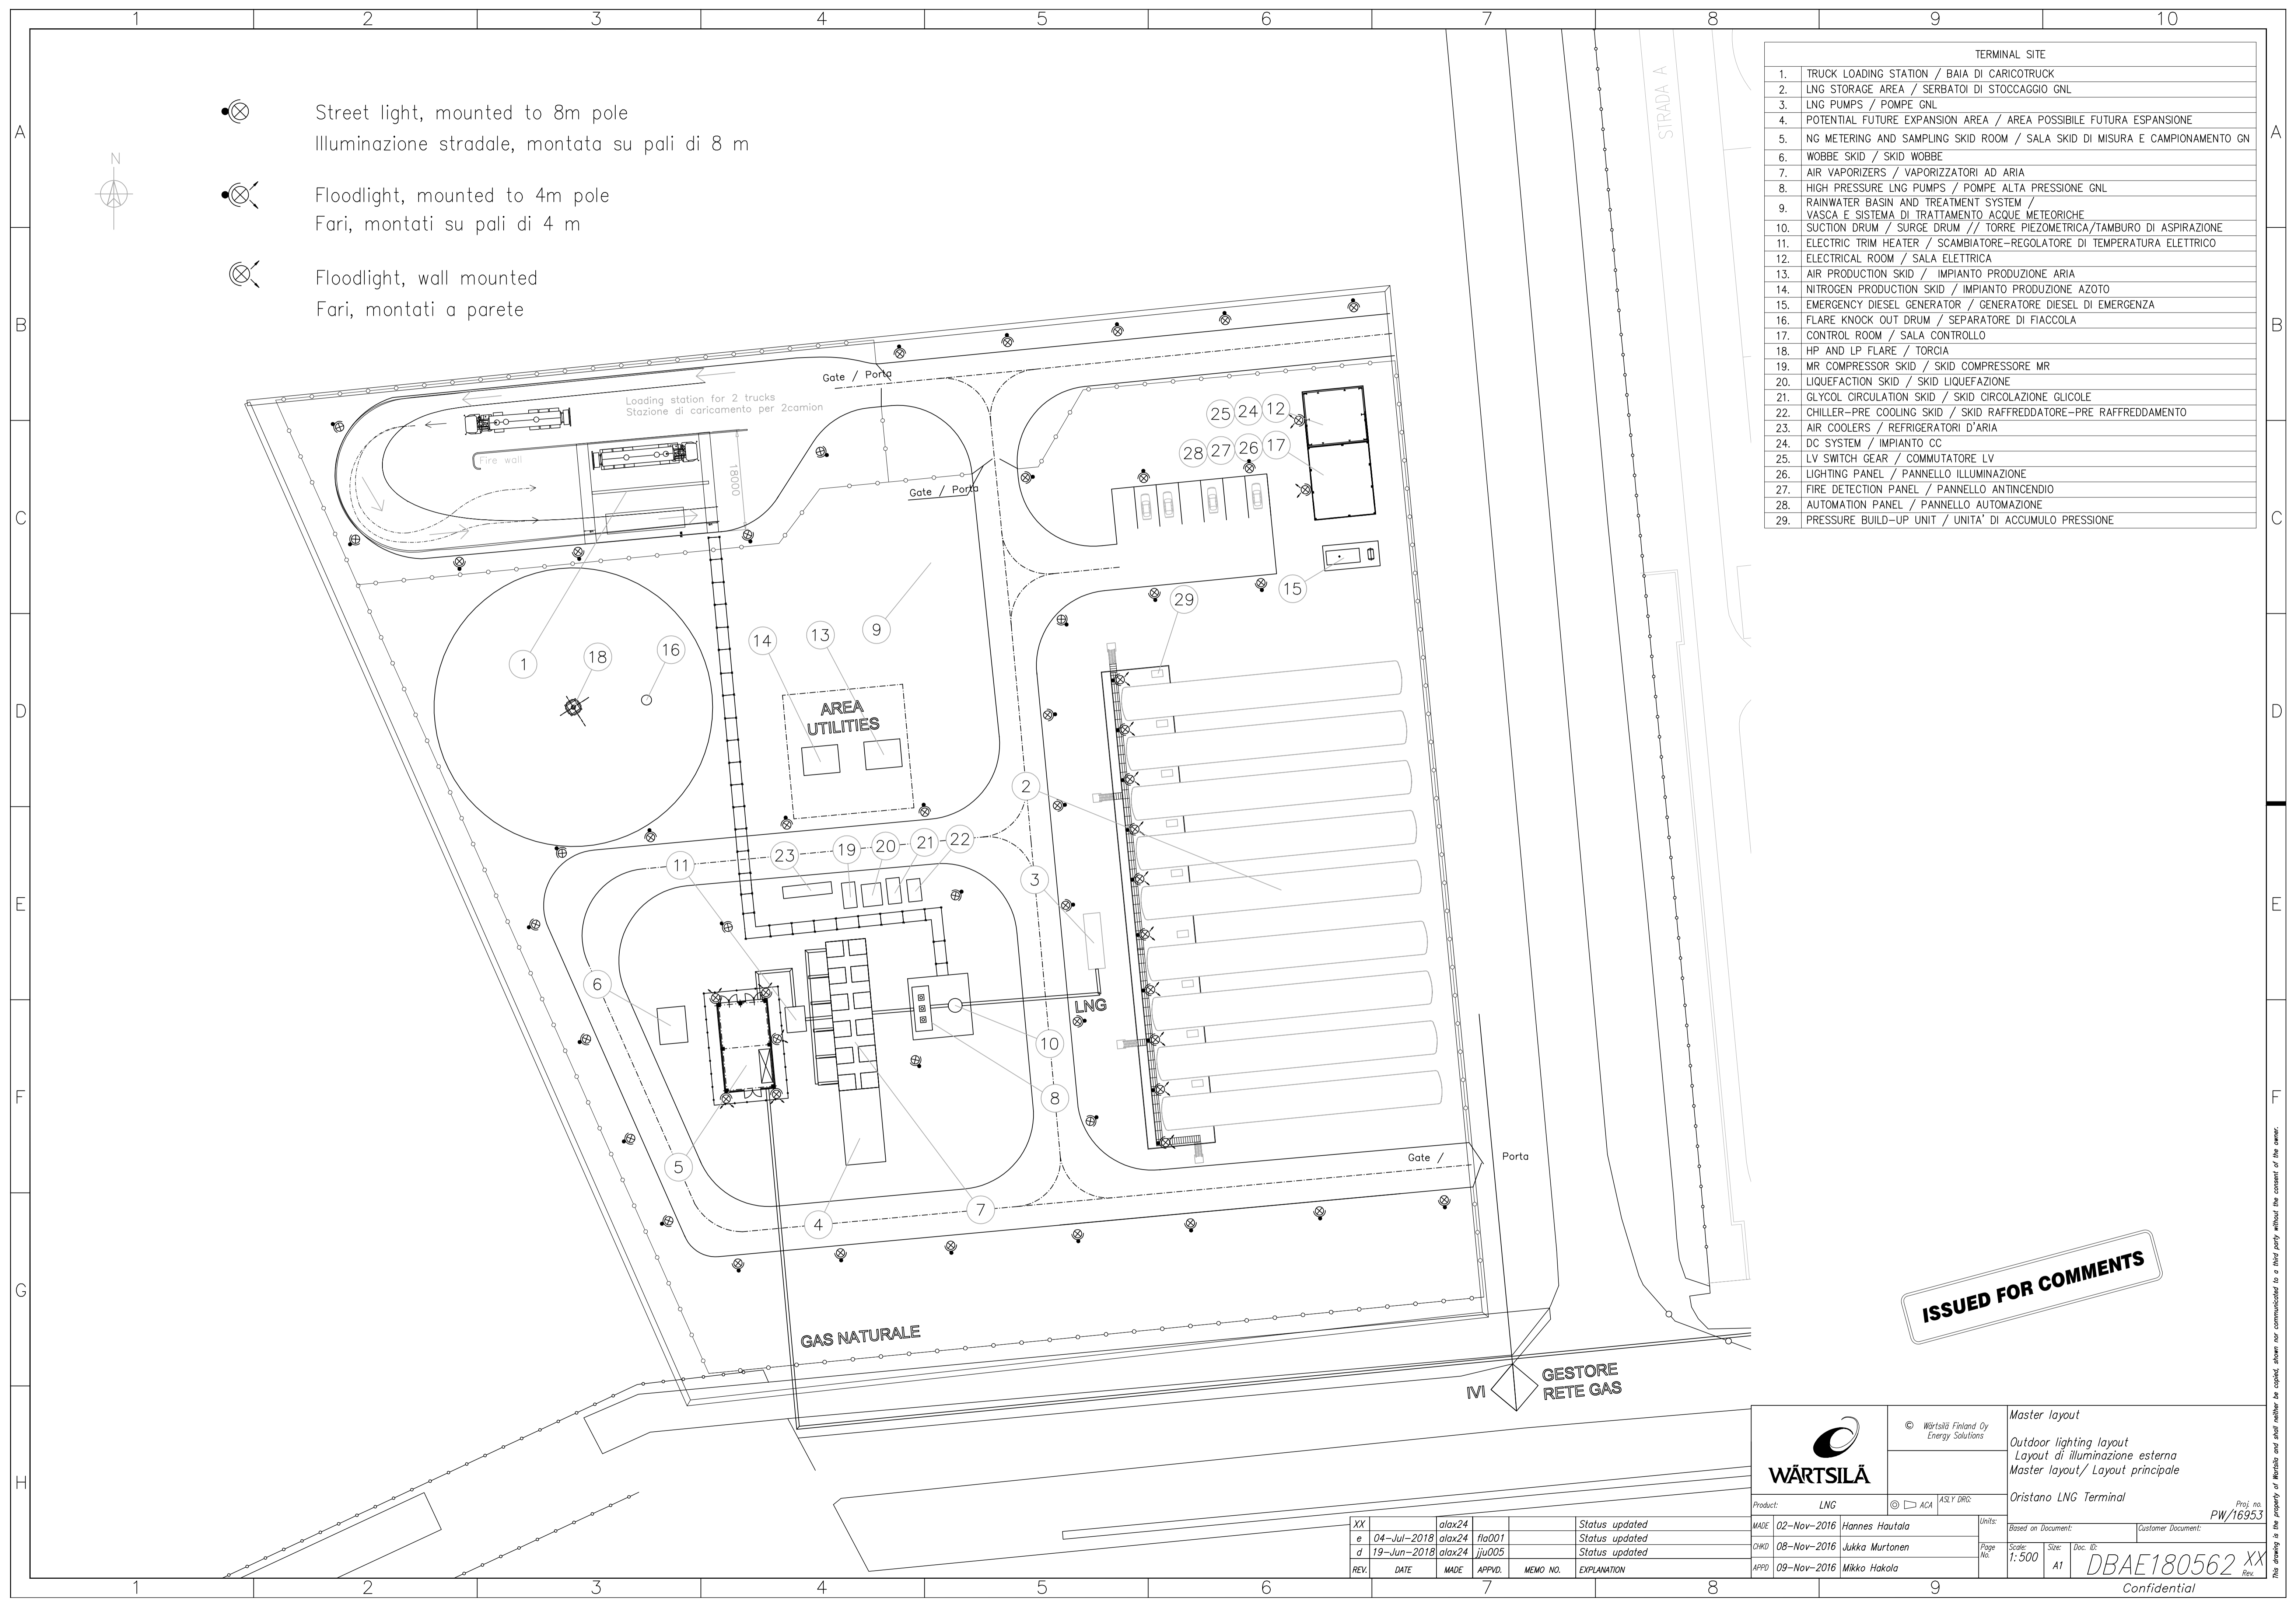



-  Street light, mounted to 8m pole  
 Illuminazione stradale, montata su pali di 8 m
-  Floodlight, mounted to 4m pole  
 Fari, montati su pali di 4 m
-  Floodlight, wall mounted  
 Fari, montati a parete

TERMINAL SITE	
1.	TRUCK LOADING STATION / BAIÀ DI CARICOTRUCK
2.	LNG STORAGE AREA / SERBATOI DI STOCCAGGIO GNL
3.	LNG PUMPS / POMPE GNL
4.	POTENTIAL FUTURE EXPANSION AREA / AREA POSSIBILE FUTURA ESPANSIONE
5.	NG METERING AND SAMPLING SKID ROOM / SALA SKID DI MISURA E CAMPIONAMENTO GN
6.	WOBBE SKID / SKID WOBBE
7.	AIR VAPORIZERS / VAPORIZZATORI AD ARIA
8.	HIGH PRESSURE LNG PUMPS / POMPE ALTA PRESSIONE GNL
9.	RAINWATER BASIN AND TREATMENT SYSTEM / VASCA E SISTEMA DI TRATTAMENTO ACQUE METEORICHE
10.	SUCTION DRUM / SURGE DRUM // TORRE PIEZOMETRICA/TAMBURO DI ASPIRAZIONE
11.	ELECTRIC TRIM HEATER / SCAMBIATORE-REGOLATORE DI TEMPERATURA ELETTRICO
12.	ELECTRICAL ROOM / SALA ELETTRICA
13.	AIR PRODUCTION SKID / IMPIANTO PRODUZIONE ARIA
14.	NITROGEN PRODUCTION SKID / IMPIANTO PRODUZIONE AZOTO
15.	EMERGENCY DIESEL GENERATOR / GENERATORE DIESEL DI EMERGENZA
16.	FLARE KNOCK OUT DRUM / SEPARATORE DI FIACCOLA
17.	CONTROL ROOM / SALA CONTROLLO
18.	HP AND LP FLARE / TORCIA
19.	MR COMPRESSOR SKID / SKID COMPRESSORE MR
20.	LIQUEFACTION SKID / SKID LIQUEFAZIONE
21.	GLYCOL CIRCULATION SKID / SKID CIRCOLAZIONE GLICOLE
22.	CHILLER-PRE COOLING SKID / SKID RAFFREDDATORE-PRE RAFFREDDAMENTO
23.	AIR COOLERS / REFRIGERATORI D'ARIA
24.	DC SYSTEM / IMPIANTO CC
25.	LV SWITCH GEAR / COMMUTATORE LV
26.	LIGHTING PANEL / PANNELLO ILLUMINAZIONE
27.	FIRE DETECTION PANEL / PANNELLO ANTINCENDIO
28.	AUTOMATION PANEL / PANNELLO AUTOMAZIONE
29.	PRESSURE BUILD-UP UNIT / UNITA' DI ACCUMULO PRESSIONE



**ISSUED FOR COMMENTS**

REV.	DATE	MADE	APPV.	MEMO NO.	EXPLANATION
XX		alax24			Status updated
e	04-Jul-2018	alax24	fla001		Status updated
d	19-Jun-2018	alax24	juu005		Status updated



**WÄRTSILÄ**

© Wärtsilä Finland Oy  
Energy Solutions

Master layout  
Outdoor lighting layout  
Layout di illuminazione esterna  
Master layout / Layout principale

Oristano LNG Terminal

Product: LNG	ASLY DRG:	Proj no: PW/16953
MADE: 02-Nov-2016 Hannes Hautala	Units:	Customer Document:
CHKD: 08-Nov-2016 Jukka Murtonen	Page No:	Scale: 1:500
APPD: 09-Nov-2016 Mikko Hakola	Size: A1	Doc. ID: DBAE180562 XX

Confidential

This drawing is the property of Wärtsilä and shall neither be copied, shown nor communicated to a third party without the consent of the owner.