




LEGENDA APPARECCHIATURE NUOVA UNITA'	
POS.	DENOMINAZIONE IMPIANTO
1	TURBOGAS
1a	TURBINA A GAS
1b	FILTRO ARIA COMBURENTE
1c	GENERATORE
1d	AREA SISTEMA CCCW
1e	AIR COOLER AUX
2	CALDAIA A RECUPERO E CAMINO
3	TURBINA A VAPORE
3a	CONDENSATORE
3b	GENERATORE
4	TRASFORMATORI
5	EDIFICIO SERVIZI INDUSTRIALI
6	EDIFICIO ELETTRICO
8	CAMINO DI BY-PASS
10	NUOVA STAZIONE GAS NATURALE
11	AREA DI STOCCAGGIO BOMBOLE CO2 - H2
12	VASCA PRIMA PIOGGIA
14	GENERATORE DIESEL EMERGENZA
15	VASCA POMPE ACQUA DI MARE SERVIZI

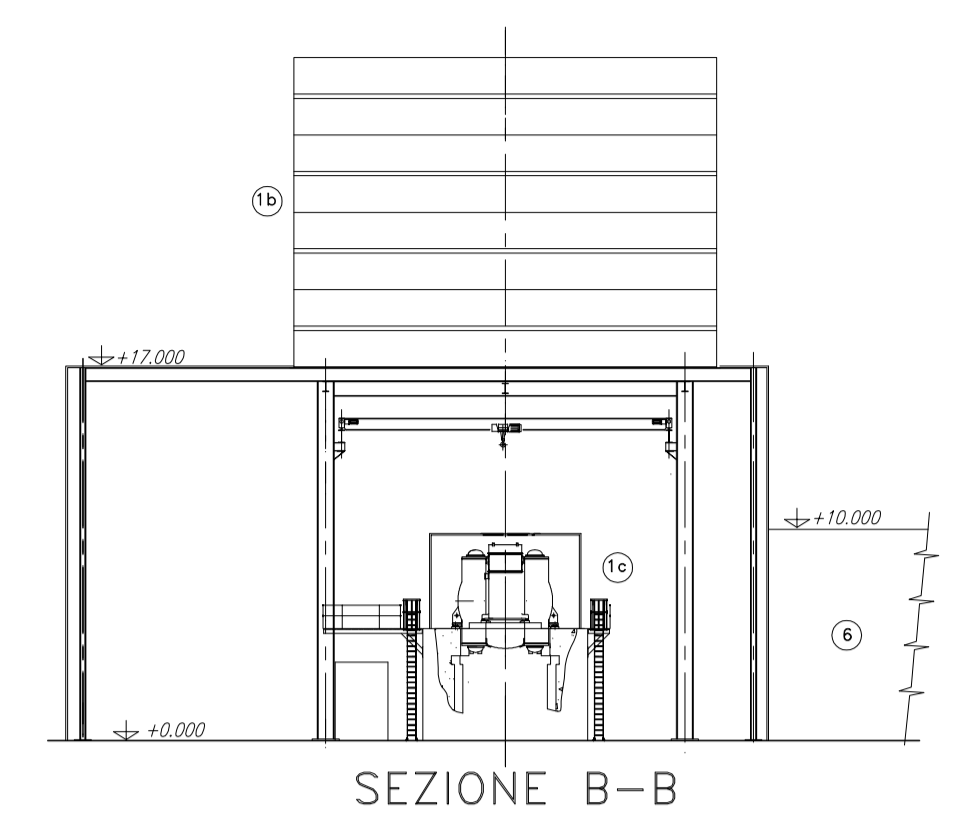


SEZIONE B-B

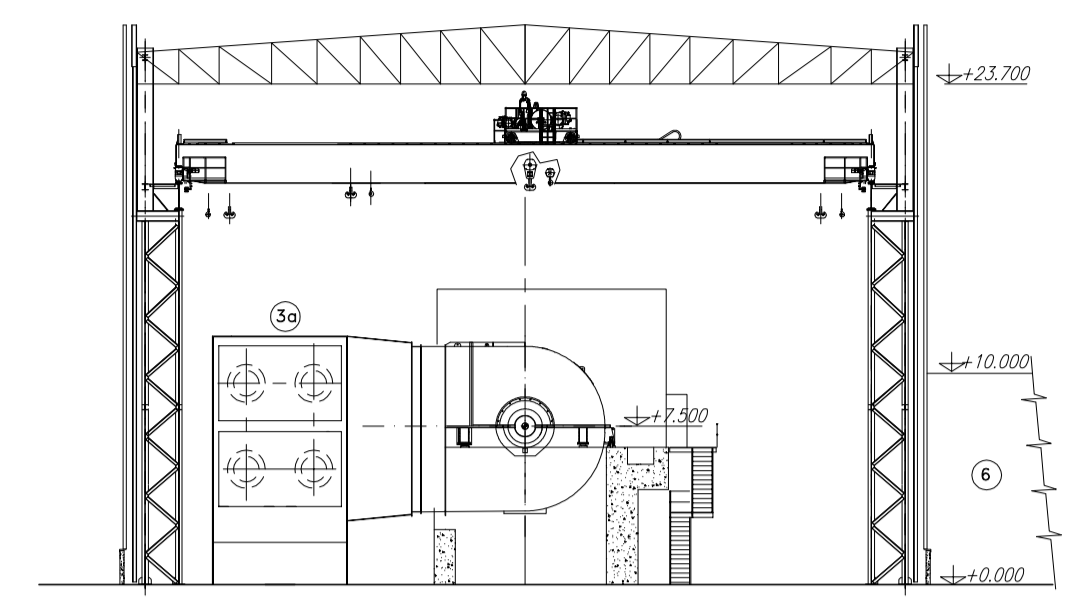


SEZIONE C-C

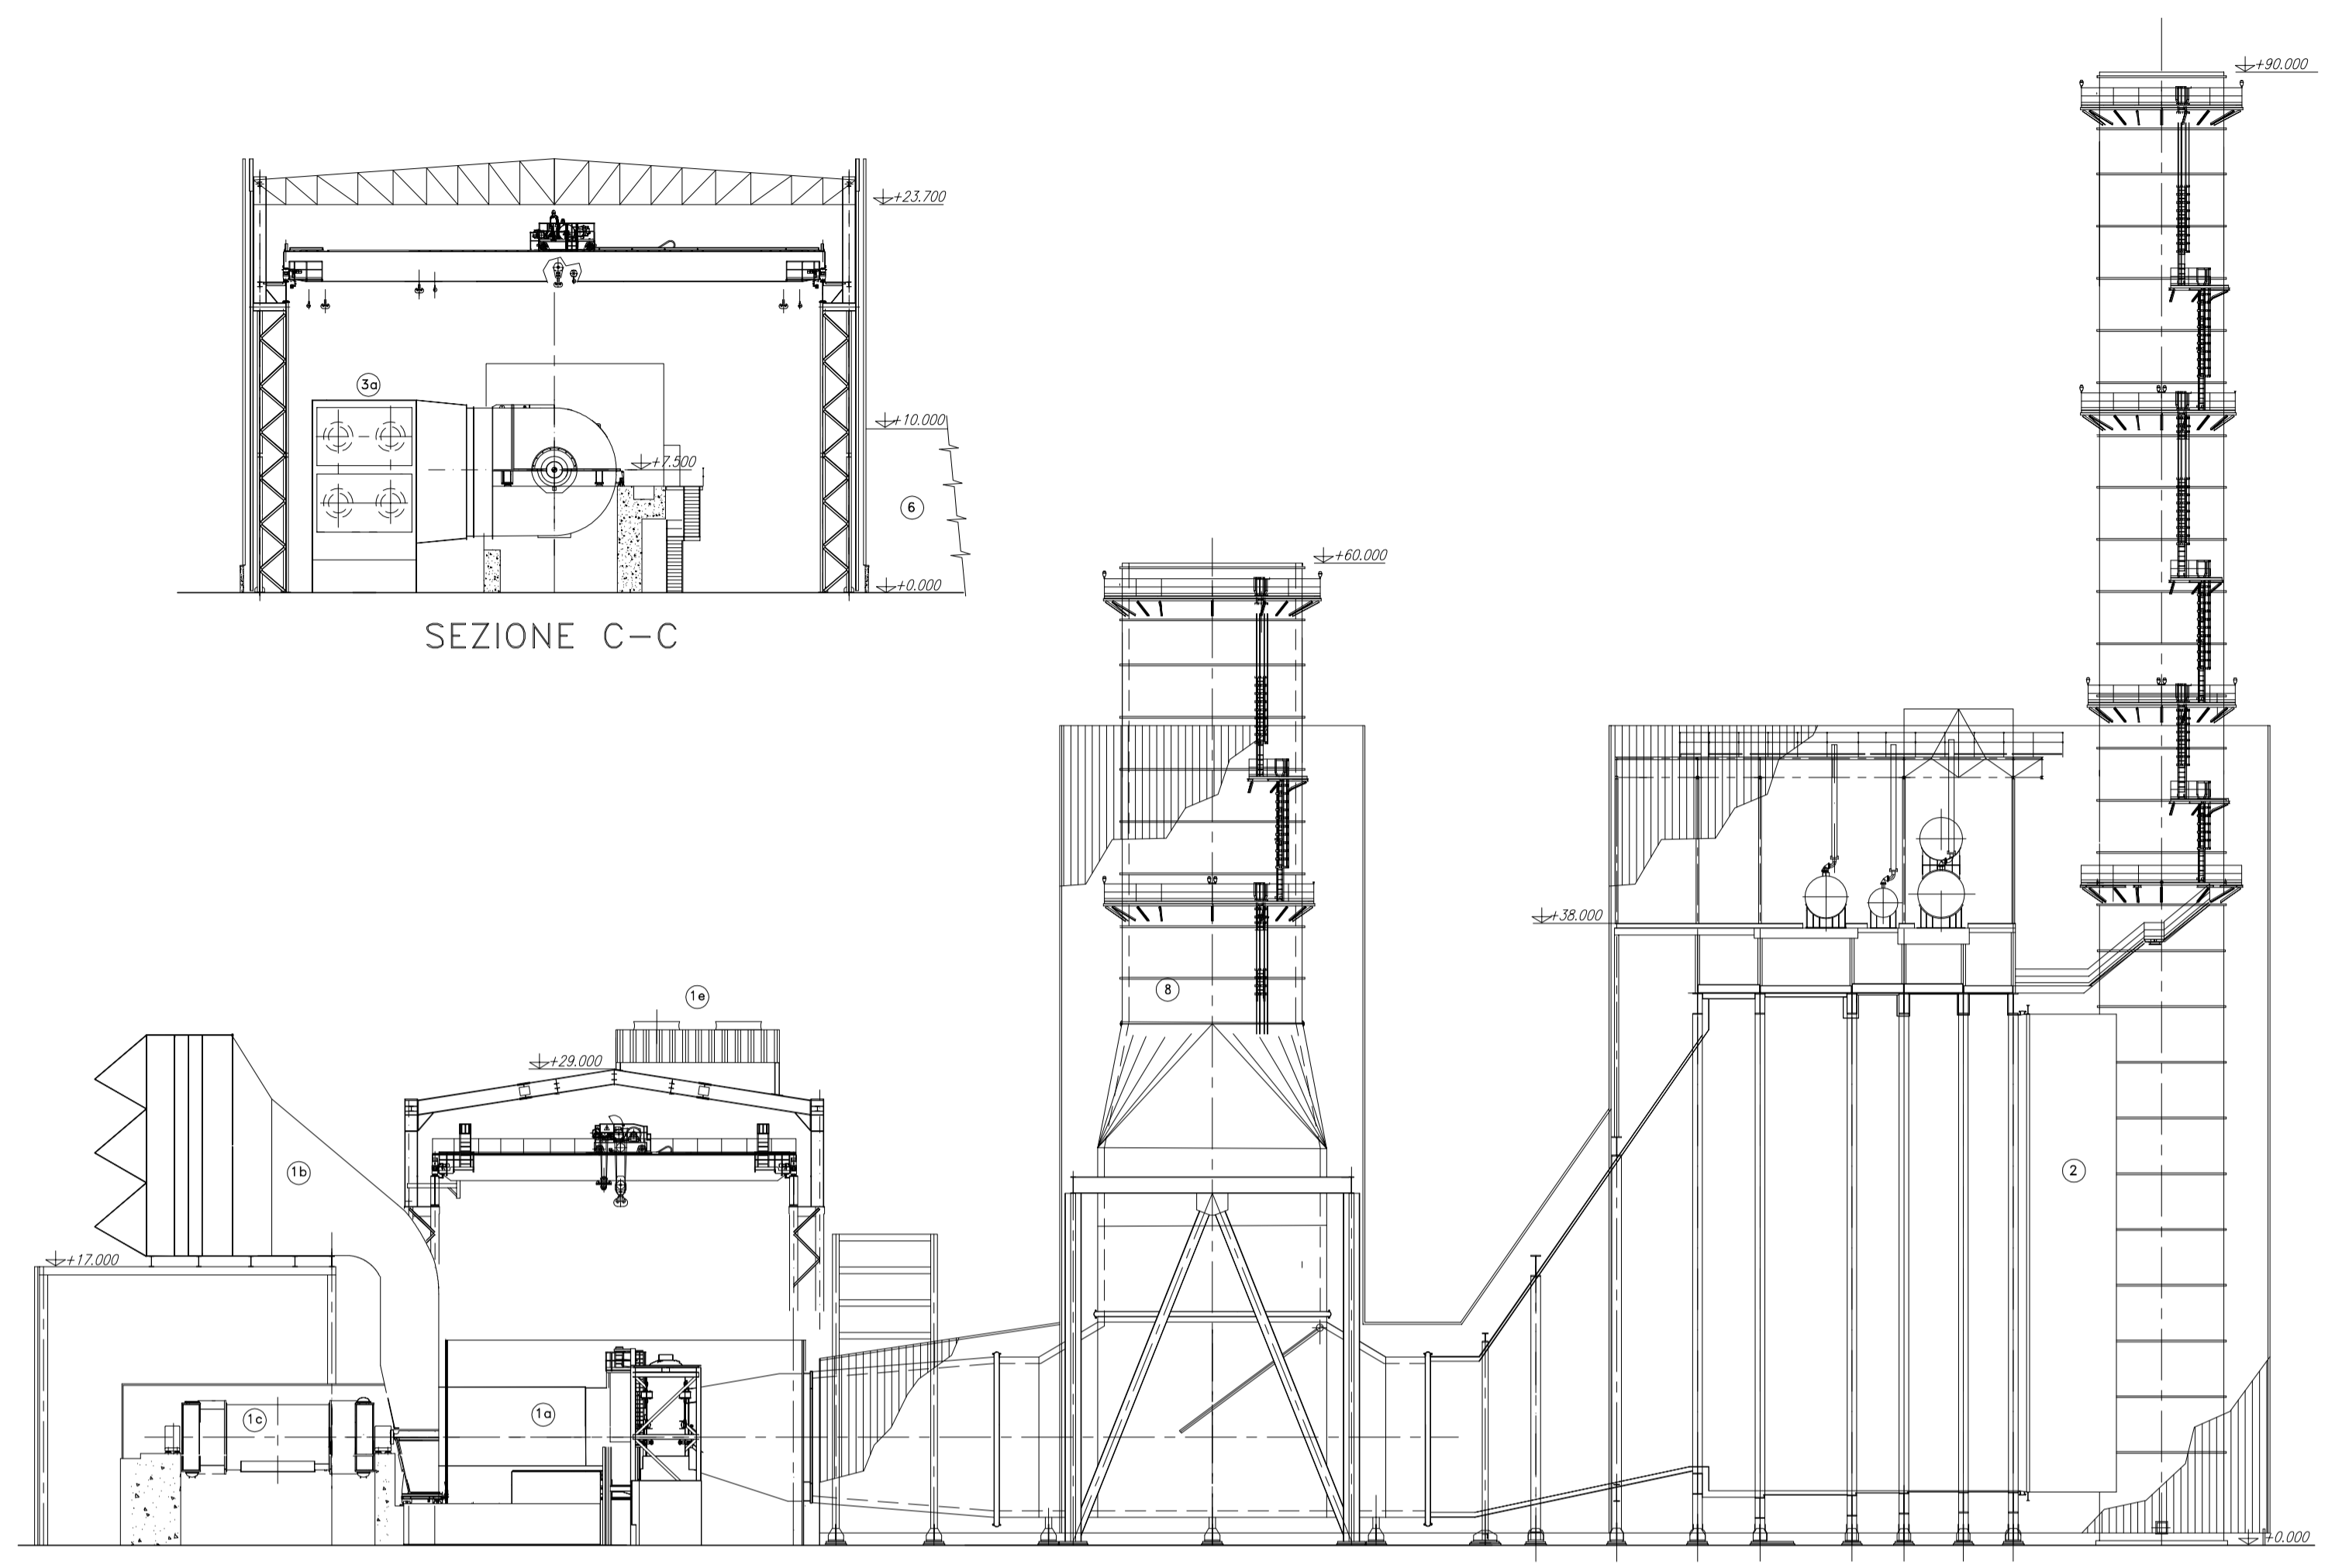

SEZIONE A-A

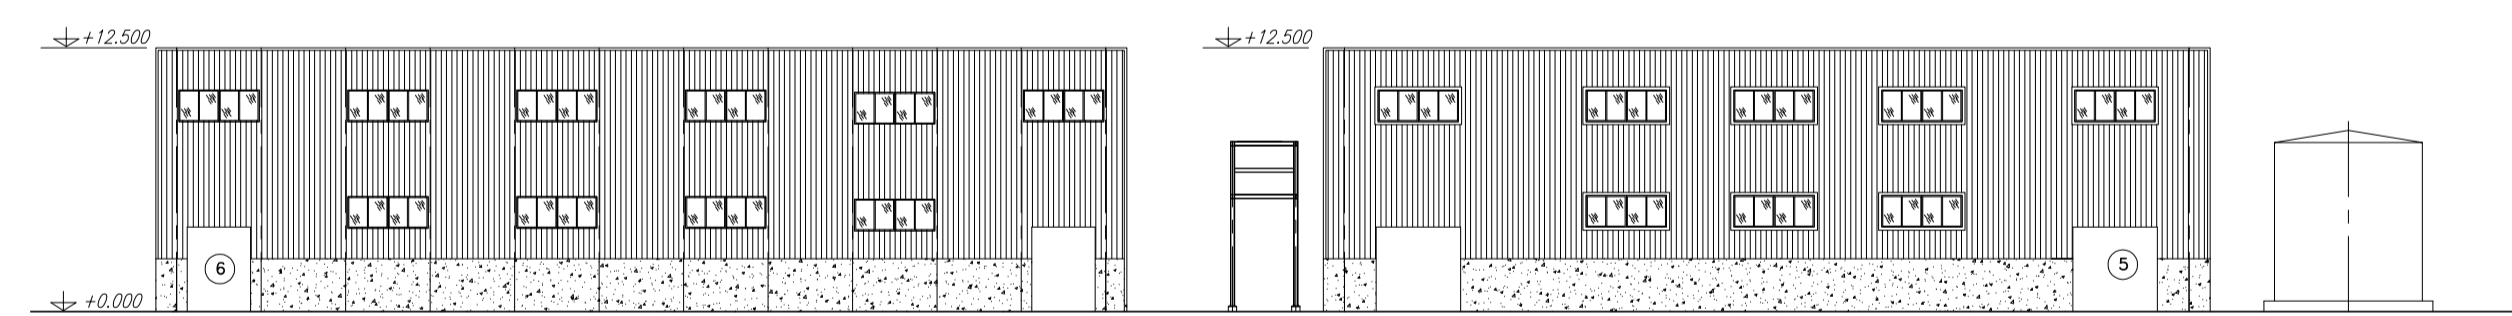

SEZIONE E-E

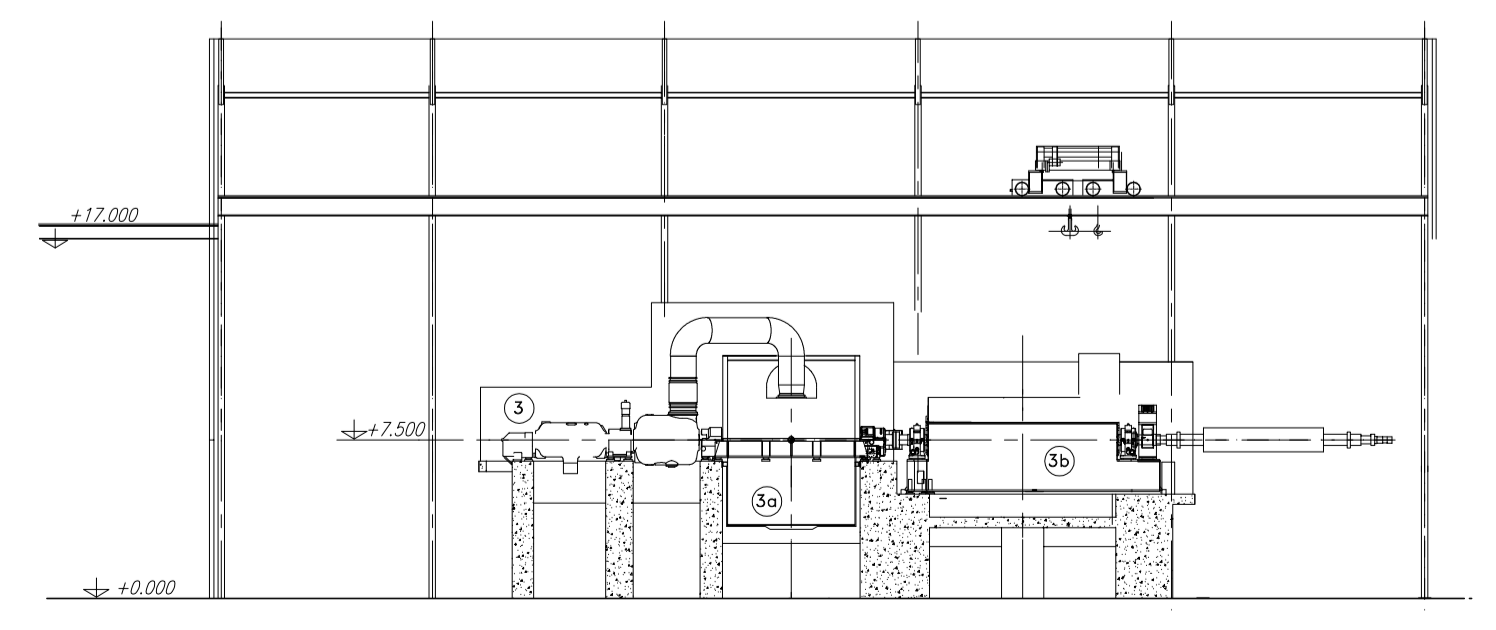

SEZIONE D-D

DISEGNI DI RIFERIMENTO (PER USO ENEL)
PBITC00253_02

NOTE	
1	ELEVAZIONI IN MM

REV.	DATE	SCOPE	REVISION DESCRIPTION	PREPARED BY	COOPERATIONS	APPROVED BY	ISSUED BY
00	04/03/19	LC	RICHIESTA NOF VVF	PPD	PPD	PPD/FS	

CLIENT ENEL GLOBAL GENERATION - GENERATION ITALY	
JOB No.	DOC No.
PROJECT CAPACITY STRATEGY ITALY	EMPLOYER SUBMITTAL Per approvazione
TITLE FUSINA - CONFIGURAZIONE OCGT/CCGT PROGETTO PRELIMINARE ANTINCENDIO VISTE E SEZIONI	FOR APPROVAL FOR REVISIONS ONLY NOT RECORDED New releases SYSTEM Sistema
SCALE 1:500	DATE PBITC00738
FILE NAME PBITC0073800.dwg	REVISIONS 01 - 01

THIS DOCUMENT IS PROPERTY OF ENEL SpA. IF IT IS STRICTLY CONFIDENTIAL TO APPROVED, THIS DOCUMENT, WHOLLY OR PARTIALLY, AND IT'S INFORMATION SHOULD BE KEPT IN CONFIDENCE AND NOT TO BE DISCLOSED TO OTHERS WITHOUT PREVIOUS WRITTEN CONSENT.