








The sole responsibility of this publication lies with the author. The European Union is not responsible for any use that may be made of the information contained therein.

LEGEND/LEGENDA


ROUTE LEGEND /SIMBOLOGIA CARTOGRAFICA

-  Onshore Pipeline in Project / Metanodotto in progetto a terra
-  Offshore Pipeline in Project / Metanodotti in progetto in mare
-  Plant in Project / Impianto in progetto and relevant access road / e strada di accesso relativa
-  Crossing with HDD or Microtunnel / Attraversamento con HDD o Microtunnel

MECHANICAL LEGEND /SIMBOLOGIA MECCANICA



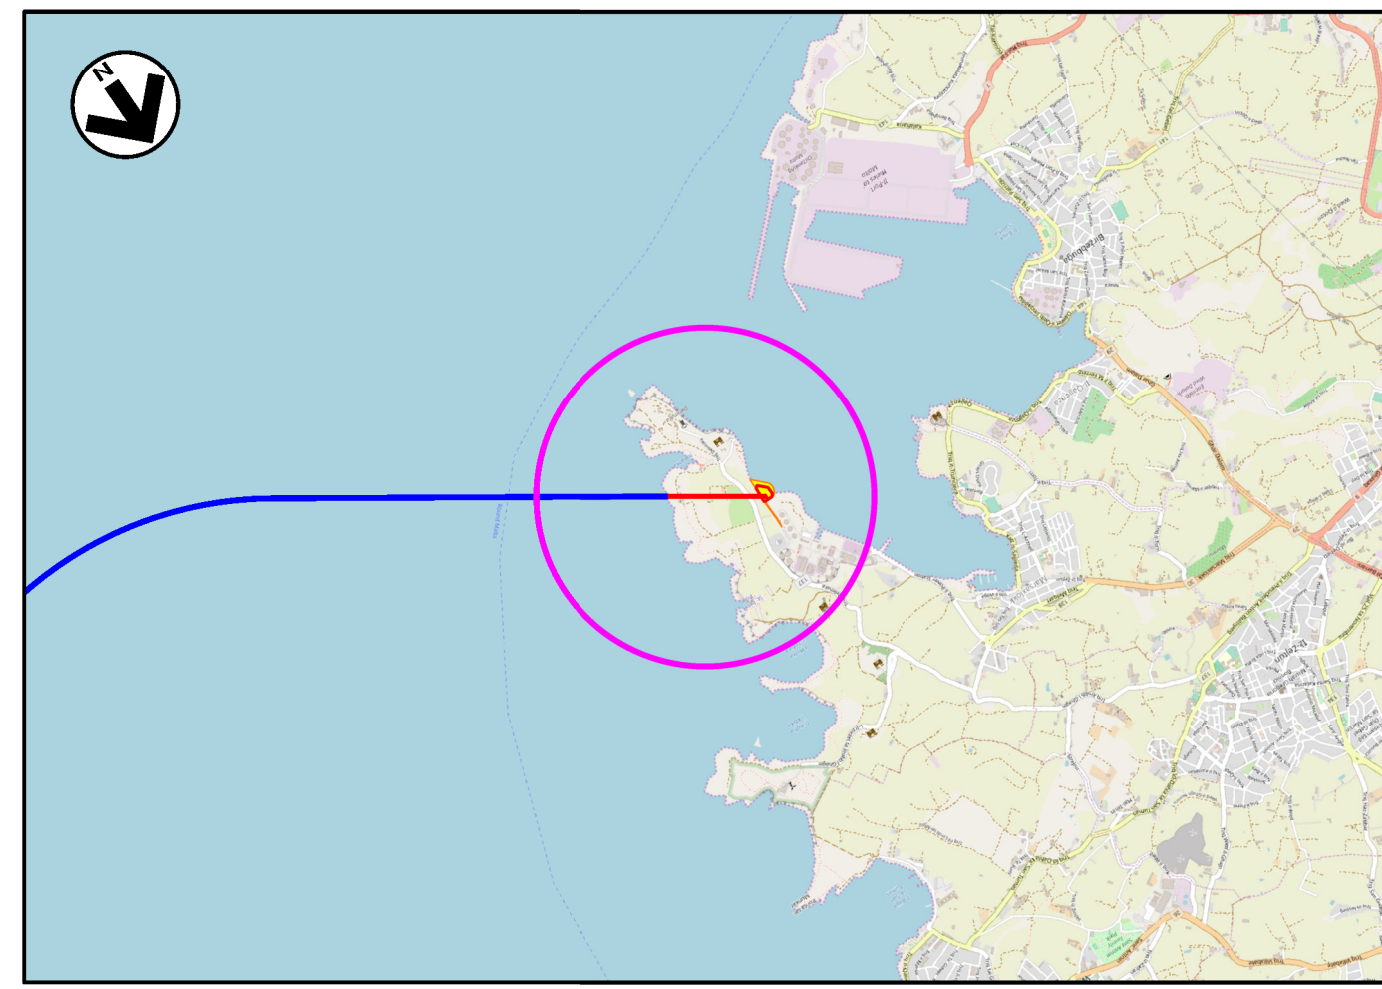

-  Valve Station (V.S.) / Punto di intercettazione di linea
-  Latching/Receiving Pig Trap Area / Stazione predisposta per lancio e ricevimento PIG
-  Regulation/Reduction Pressure Station / Impianto di riduzione/regolazione della pressione

REFERENCE DOCUMENTS	N



ROUTE MAP/COROGRAFIA

SCALE/SCALA 1:50.000

 MINISTRY FOR ENERGY AND WATER MANAGEMENT WSC, GORBIER ROAD, LUQA, MALTA  Co-financed by the European Union Connecting Europe Facility	 	CONTRACT N. CT 3108/2018	JOB Commissa 171001
	LOCATION/LOCALITA' MALTA	Document No / N Documento 10-RT-E-5100 ANNEX 2 / ANNESSO 2	
PROJECT PROGETTO	MELITA TRANSGAS PIPELINE		REVISION REVISIONE
DOCUMENT TITLE TITOLO DEL DOCUMENTO	PIPELINE ROUTE IN MALTA WITH PHOTO POINT OF VIEW TRACIATO DI PROGETTO A MALTA CON RICOGNIZIONE FOTOGRAFICA		6
		SHEET/FG	1 OF/DI 2
		SCALE/SCALA	
		1 : 5000	

PROJECT/PROGETTO
MELITA TRANSGAS PIPELINE

KEY PLAN
QUADRO D'UNIONE

2

Sheet
Foglio
2
of/di 2

DOCUMENT TITLE/TITOLO DEL DOCUMENTO
**PIPELINE ROUTE IN GELA WITH PHOTO POINT OF VIEW
TRACCIATO DI PROGETTO A MALTA CON RICOGNIZIONE FOTOGRAFICA**



DWG No /DIS N
**10-RT-E-5100
ANNEX 2 /ANNESSO 2**

JOB
Commissa **171001**

Scale/Scala
1:5000



Lenght/Progressiva chilometrica (Km)	158	158 + 610	159 + 257	159 + 310
City /Comune (Provincie /Provincia)	DELIMARA (MARSAXLOKK)			
Region /Regione (Country /Stato)	MALTA / MALTA (MALTA / MALTA)			
Plants /Impianti	PIG TRAP STATION Km. 159+310			
Crossings /Attraversamenti	ROAD "TRIO DELIMARA" / STRADA "TRIO DELIMARA"			
Access road for plant / Strada di accesso impianto				
Restraintment Works/Lavori di Ripristino				

The sole responsibility of this publication lies with the author. The European Union is not responsible for any use that may be made of the information contained therein.