



PLAN VIEW - EL. -0.50

SCALE 1:100

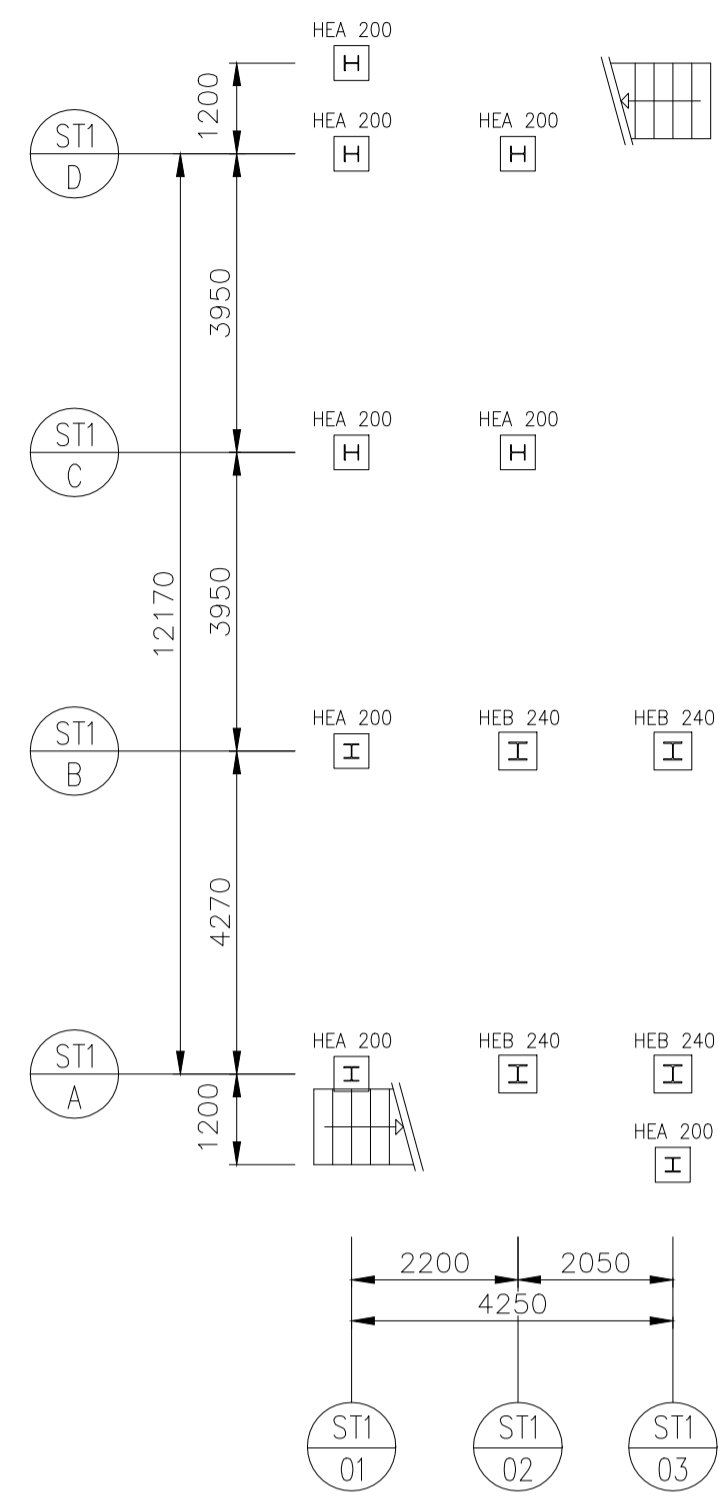

PLAN VIEW - EL. +2.90

SCALE 1:100

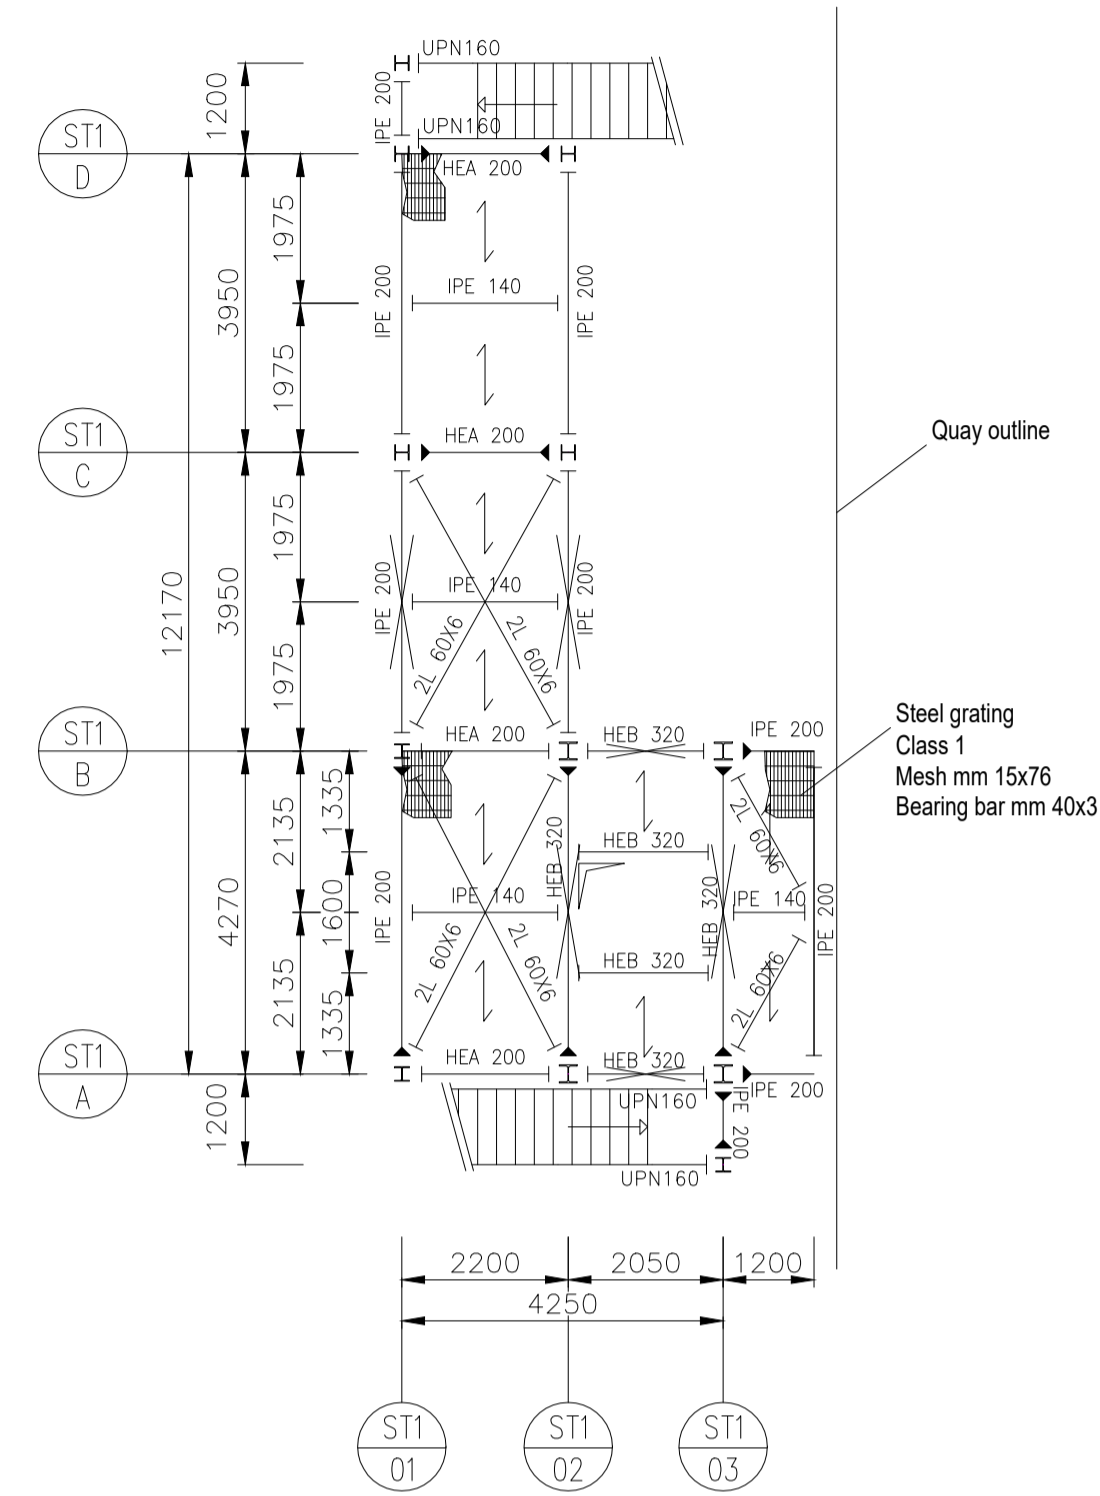

**GENERAL NOTE:**  
 PASSIVE FIRE PROTECTION - EPOXY INTUMESCENT COATING R 90 TO BE APPLIED TO ALL STRUCTURAL STEEL MEMBERS SHOWN IN THIS DRAWING (EXCLUDING GRATING/METAL SHEET AS APPLICABLE)

REFERENCE DRAWINGS / DISEGNI DI RIFERIMENTO

DWG. N° / N° DIS	DESCRIPTIONS / DESCRIZIONE
0469-TITA-P-PP-000-001	GENERAL PLOT PLAN
.....	.....
.....	.....
.....	.....
.....	.....

NOTES

- 1 - ALL DIMENSIONS ARE IN MM AND ALL ELEVATIONS ARE IN M.
- 2 - THE REFERENCE ELEVATION ± 0.000 M CORRESPONDES TO +2.500 M A.S.L.
- 3 - FOR BUILDING FOUNDATION REFER TO DDC. 0469-TITA-C-GD-000-001 GENERAL FOUNDATION PLAN
- 4 - LIVE LOAD 3kN/m<sup>2</sup>

MATERIAL LIST


STEEL PROFILES S275JR  
 HIGH STRENGTH BOLTS C1.8.8 ; NUT C1.8

LEGEND

- G.L. = GRADE LEVEL
  - T.O.G. = TOP OF GRATING
  - B.O.P. = BOTTOM OF PLATE
  - T.O.C. = TOP OF CONCRETE
  - B.O.S. = BOTTOM OF STEEL
  - T.O.S. = TOP OF STEEL
- MOMENT CONNECTION IN THE PLAN  
 MOMENT CONNECTION IN THE ELEVATION  
 SHEAR CONNECTION


THE INFORMATION CONTAINED IN THIS DRAWING IS TO BE CONSIDERED PRELIMINARY AND SHALL BE DULY VERIFIED DURING THE DETAIL DESIGN PHASE. THE STRUCTURE SHALL BE VERIFIED ACCORDING TO THE EXACT POSITION AND LOADS OF THE MARINE LOADING ARM.

KEY PLAN

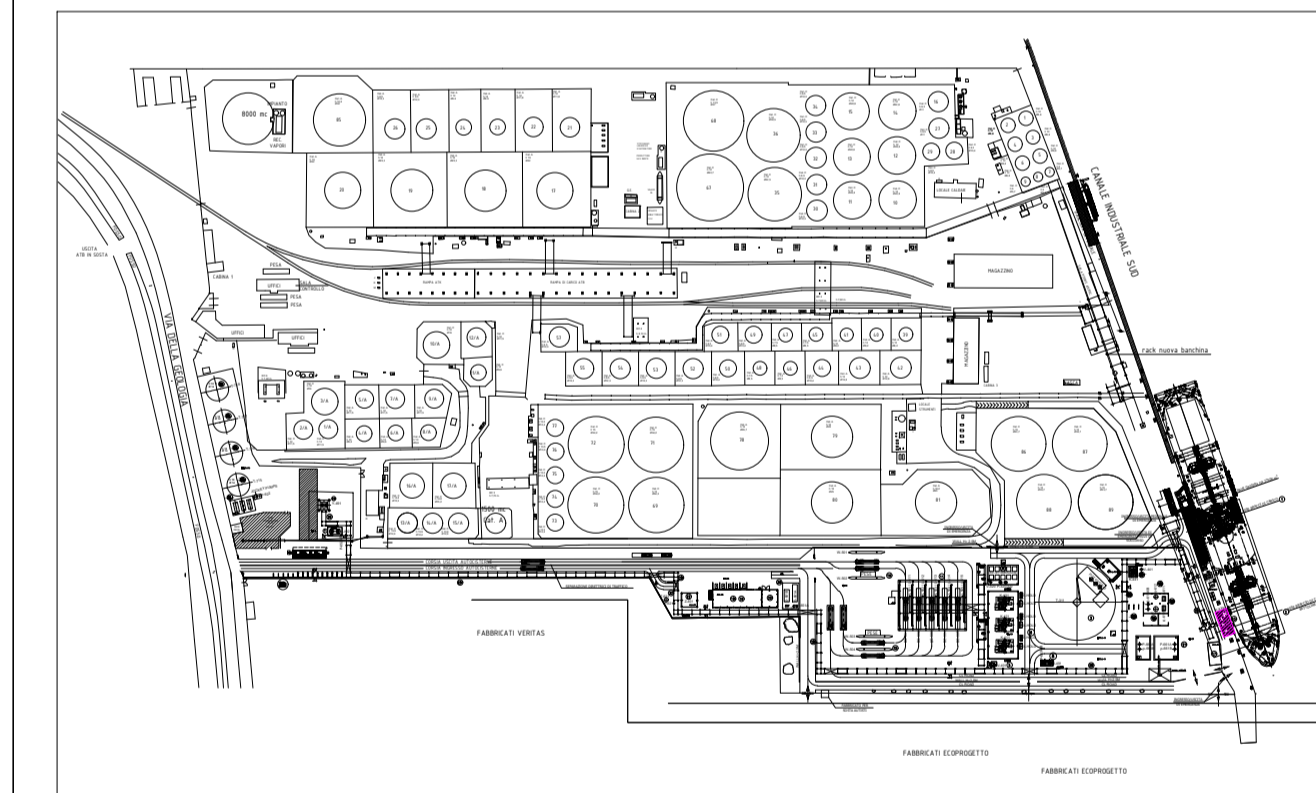


VIEW ST1-01

SCALE 1:100

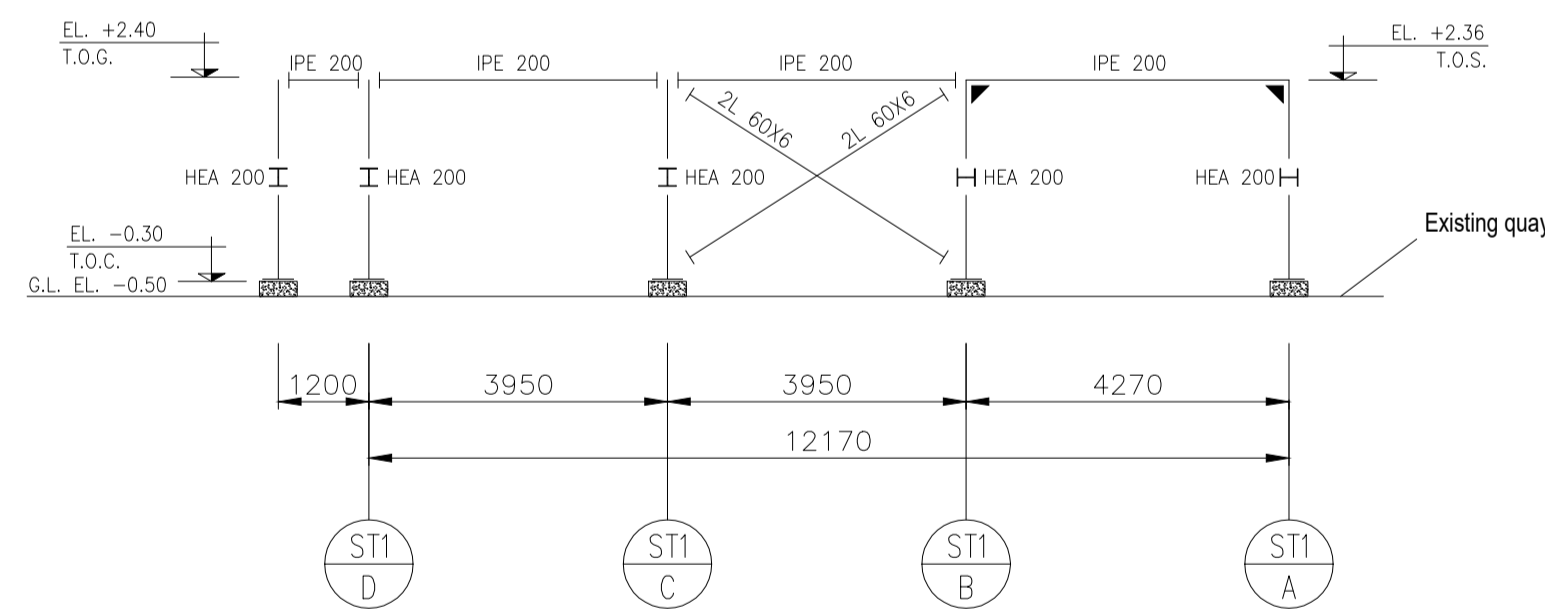


VIEW ST1-02

SCALE 1:100

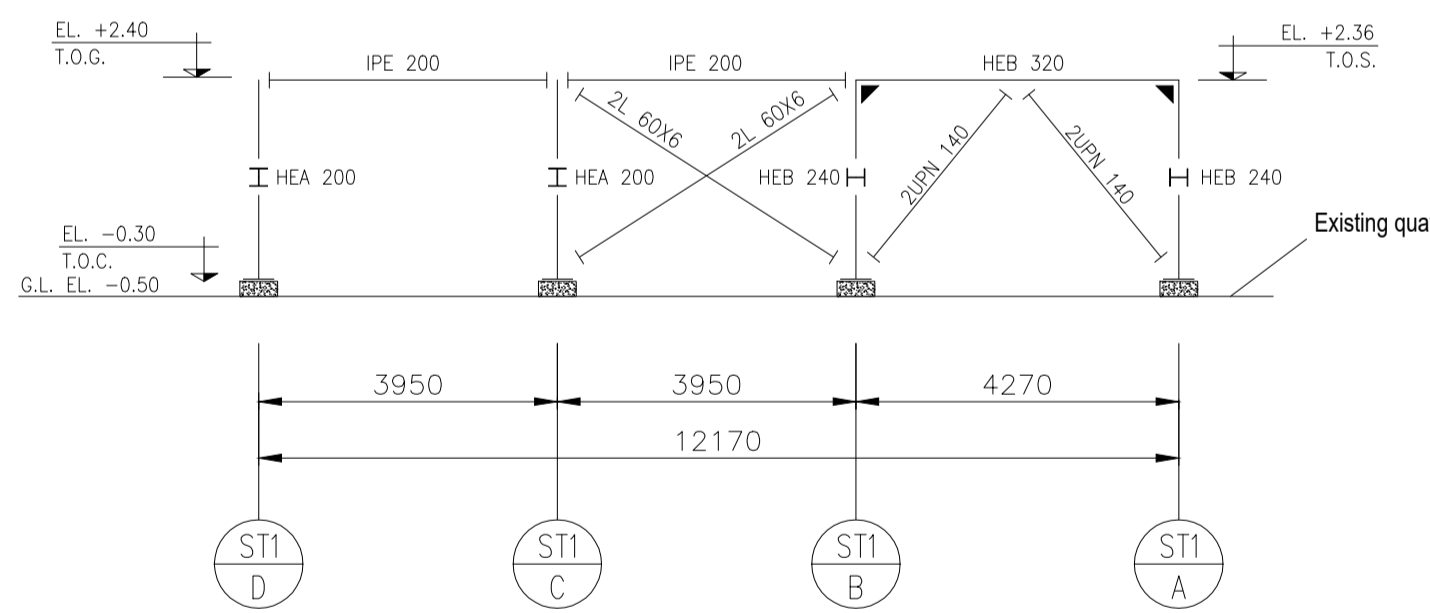


VIEW ST1-03

SCALE 1:100

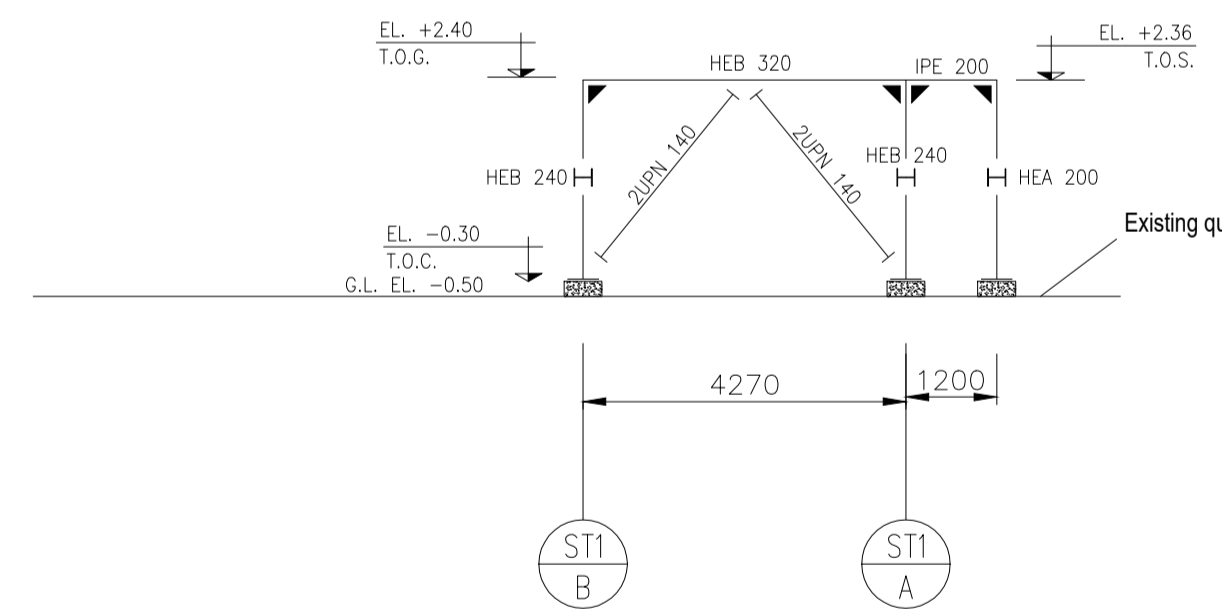


VIEW ST1-A/B

SCALE 1:100

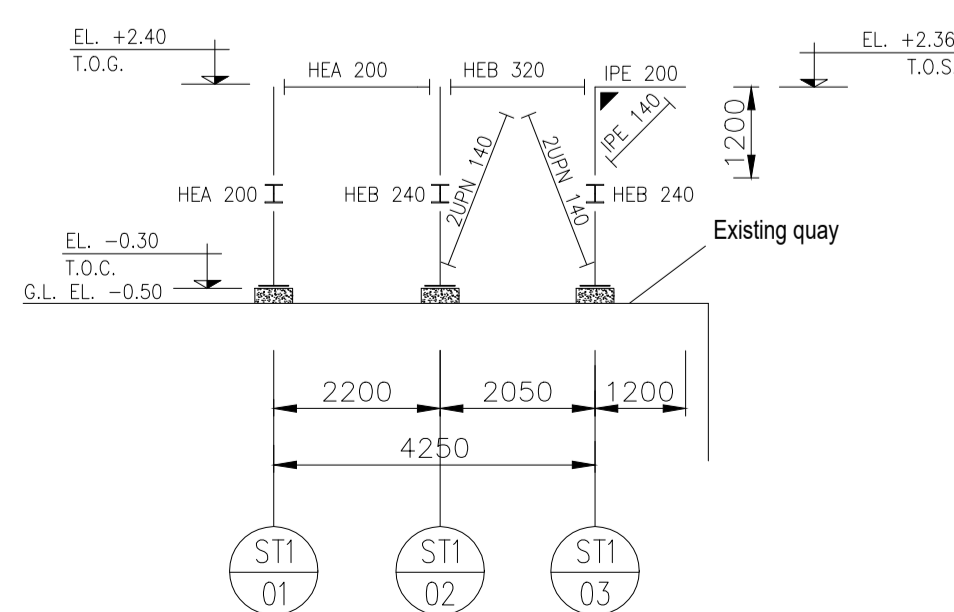

VIEW ST1-C/D

SCALE 1:100

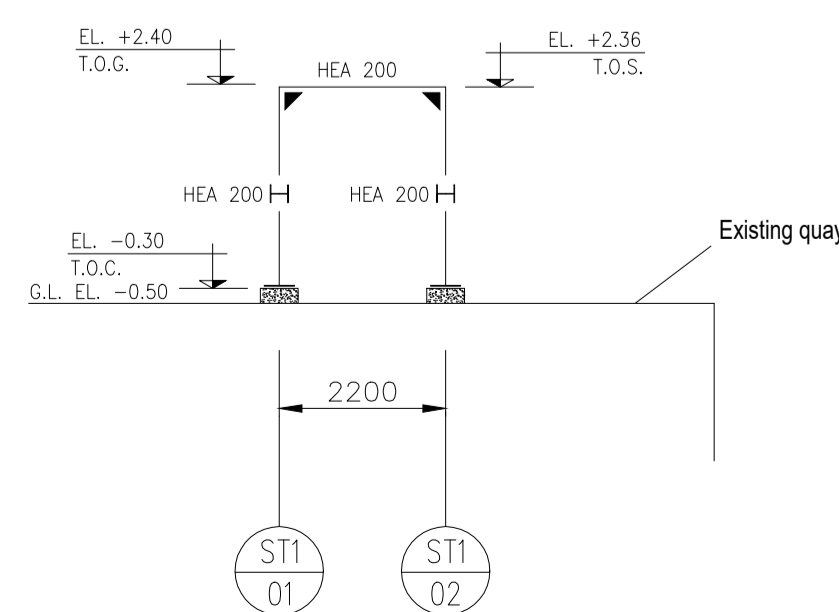

NO.	DESCRIPTION - Descrizione	PROG. - Prog.	CONTR. - Contr.	APP. - Appr.	REV. APPR. - Appr.	DATE - Data
01	FOR USE	SGL	GCA	DMR	CMA	09/09/20
00	FOR COMMENTS	SGL	GCA	DMR	CMA	20/07/20

CONTRACTOR: **TECHINT** Engineering & Construction

COMPANY: **VeniceLNG**

PROJECT TITLE: VENICE LNG FEED - VENICE LNG TERMINAL (PORTO MARGHERA)

TITLE: LNG BERTH LOADING PLATFORM STEEL STRUCTURES PLAN AND SECTIONS

SCALE: 1:100	FORM: A1	CONTRACTOR DOC. N°: 0469-TITA-S-DD-001-001	REV. 01	SHT. 1	OF 1
--------------	----------	--	---------	--------	------

CAD FILE N°

La TECHINT si riserva la proprietà di questo disegno con la proibizione di riprodurlo o trasferirlo a terzi senza autorizzazione scritta. This document is property of TECHINT. Reproduction and divulgation forbidden without written permission.