


LEGENDA	
	CIRCUIT BREAKER
	DISCONNECTOR
	DISCONNECTOR SWITCH
	THERMOMAGNETIC CIRCUIT BREAKER
	ENERGY METER
	MEASUREMENT DEVICE
	TRANSFORMER
	CURRENT TRANSFORMER
	VOLTAGE TRANSFORMER
	FUSE
	VOLTAGE LAMP
	RESIDUAL CURRENT DEVICE
	CIRCUIT BREAKER OR DISCONNECTOR MOTOR
	COMMAND COIL
	SURGE ARRESTER
	EARTH - GROUND
	MECHANICAL INTERLOCKING
	CABLE TERMINAL
	CONNECTION BETWEEN CONDUCTORS
	WITHDRAWABLE CONNECTION
	GENERATOR
	BATTERY RACK
	SINGLE STAGE CONVERTER

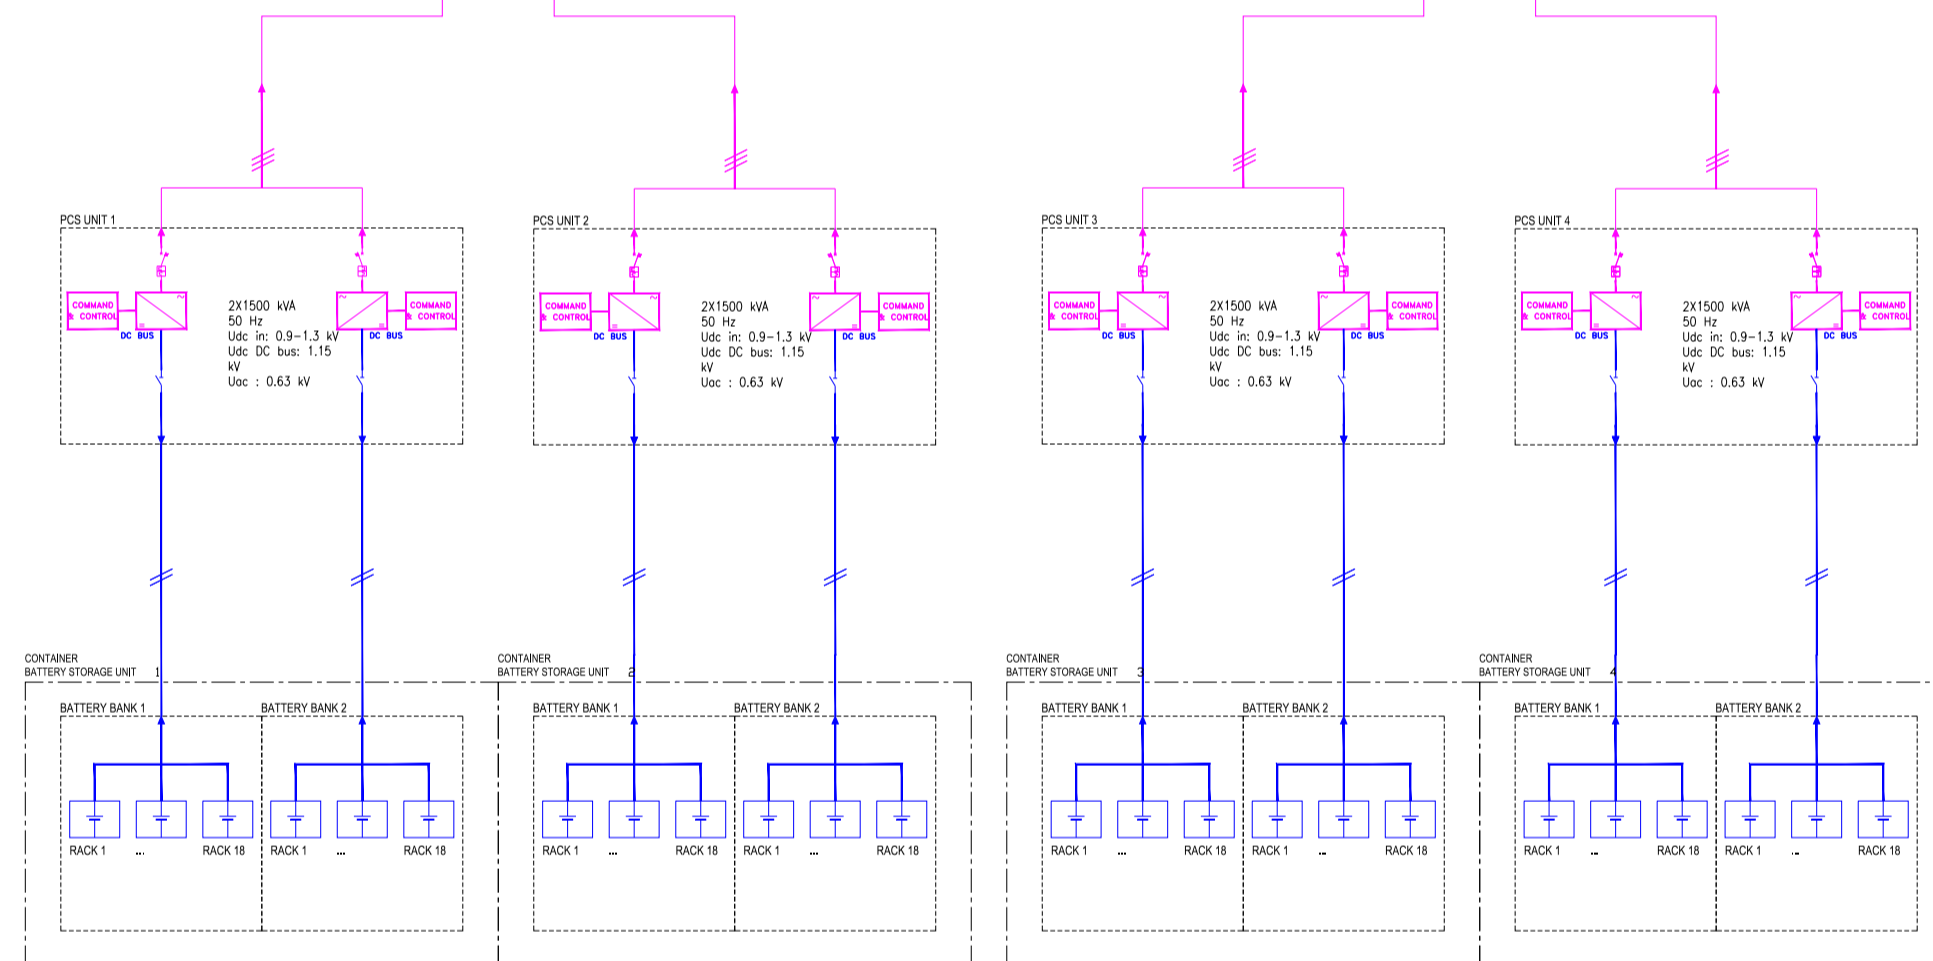



MINISTERO DELLA
TRANSIZIONE
ECOLOGICA



REGIONE VENETO



COMUNE
DI
ROVIGO

CORTE SAN MARCO

PROGETTO AGROVOLTAICO DA 49.004,28 kWp



PRESENTAZIONE V.I.A. STATALE

PROGETTO DEFINITIVO

Elaborato:
TAV. 21

Stato di Progetto:
**SCHEMI ELETTRICI UNIFILARI
IMPIANTO DI ACCUMULO**

Project Manager
Ing. Giovanni Cis
Tel. +39 349 0737323
giovanni.cis@ingpec.eu

Studio Ambientale
ambiente
Tel. +39 041-5093820
www.ambienteingroup.com
info@ambienteingroup.com

Studio Agrotecnico
Sea Tuscia Srl
SPIN OPI ACCORDATO CON L'UNIVERSITA' DELLA TUSCIA
Seasuscia.com
info@seatuscia.com

Studio Geologico e Idraulico
SIGEO S.a.s.
Tel. +39 0425 412542
www.sigeo.info
amministrazione@sigeo.info

EPC
AIEM Group S.r.l.
Tel. +39 0425 471055
www.aiemgroup.com
info@aiemgroup.com

Progettazione Elettromeccanica
S.T.E. Energy S.r.l.
Via Sorio 120 - Padova (PD)
Tel. +39 049 29 63 900
info@ste-energy.com

Relazione previsionale di impatto acustico
Ing. Francesco Tegazzin
SIC Studio
Tel. +39 340 5860281
info@sicstudio.it

Logistica e Coordinamento
Ing. Giuseppe Romani
Tel. 333 3009981
ing.romani@gmail.com

Calcoli Strutturali
Ing. Stefano Baldo
Tel. 349 442244
ing.stefanobaldo@gmail.com

Rev.	Data	Oggetto della revisione	Elaborazione	Verifica	Approvazione
00	Dicembre 2021	Emissione per progetto definitivo	Mihai Bondac	Ing. Giuseppe Romani	Ing. Giovanni Cis

Formato: A1
SCALA: 1:5000

Società proponente

AGROVOLTAICA S.r.l.
Via Filippo 21 - 45021 Bada Padovina (RO)
P.IVA 01601730292 - www.agrovoltaca.it



AGROVOLTAICA